

PLEASANT VALLEY APARTMENTS

AUSTIN, TEXAS

GARAGE PERMIT SET

04-16-2015

PPDS

[design + interiors]

1012 mopac circle, suite 200
austin, texas 78746
512.328.1883 [p]
512.328.7448 [f]
www.pfds-inc.com
www.pfds-inc.com/blog

drawn by:
L.Wiggins

checked by:
J. Paulson


Date:
04.16.2015 PERMIT

FOR:
GARAGE PERMIT
SCALE: AS NOTED

TABLE OF CONTENTS

ID0.0	INTERIOR DESIGN COVER SHEET
ID1.0	SUB LEVEL, LEVEL 1-3 GARAGE ELEVATORS- FINISH PLAN
ID1.1	LEVEL 4-6 GARAGE ELEVATORS- FINISH PLAN
ID2.0	SUB LEVEL, LEVEL 1-3 GARAGE ELEVATORS- LIGHTING PLAN
ID2.1	LEVEL 4-6 GARAGE ELEVATORS- LIGHTING PLAN

PLEASANT VALLEY APARTMENTS
AUSTIN, TEXAS

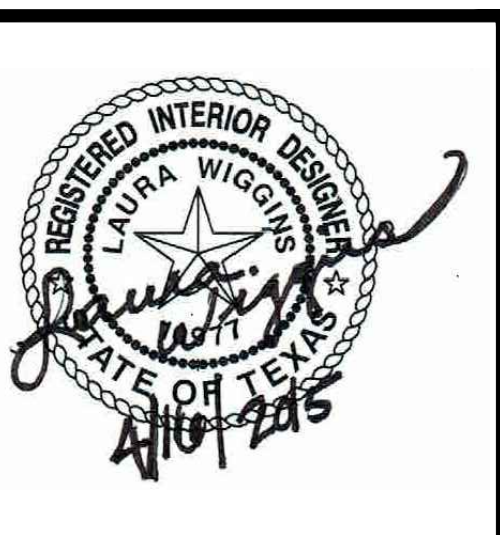

COVER SHEET

ID0.0


drawn by:
L. Wiggins

checked by:
J. Paulson


Date:
04.16.2015 PERMIT

FOR:
GARAGE PERMIT
SCALE: AS NOTED

FINISH SCHEDULE					
TAG	Description	Manufacturer	Product	Color/ Finish/ Size	Installation
Floors					
FT-1	Porcelain Floor Tile	Imola Ceramica	Koshi	Koshi CE/ 12" x 24"	Straight Lay
CON-1	Sealed Concrete				
Walls					
WT-1	Porcelain Wall Tile	Stone Source	Inessence	53K51R Miscela Sabbia/ 5-7/8" x 47-1/4"	Straight Lay
WD-1	Stained Wood Wall Planks			Stained to match Designer Sample	
WP-1	Fiberglass Panel	Modular Arts	Crush- Interlocking Rock Panel	To be painted on site	
PT-1	Paint	TBD	TBD	Color: TBD/ Finish: Satine	Throughout, U.N.O.

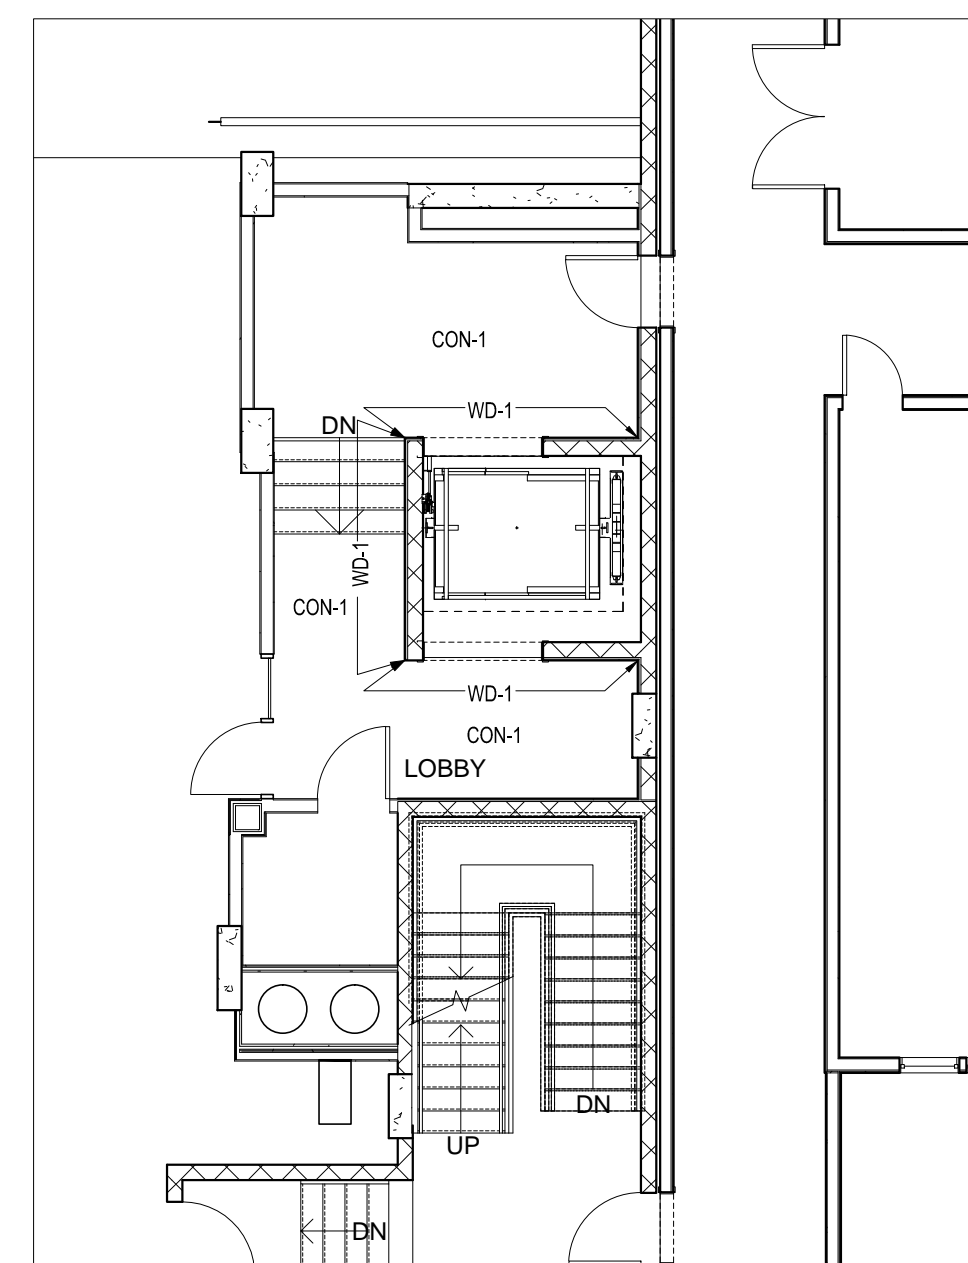


SE ELEV.
SCALE: 1/8" = 1'-0"

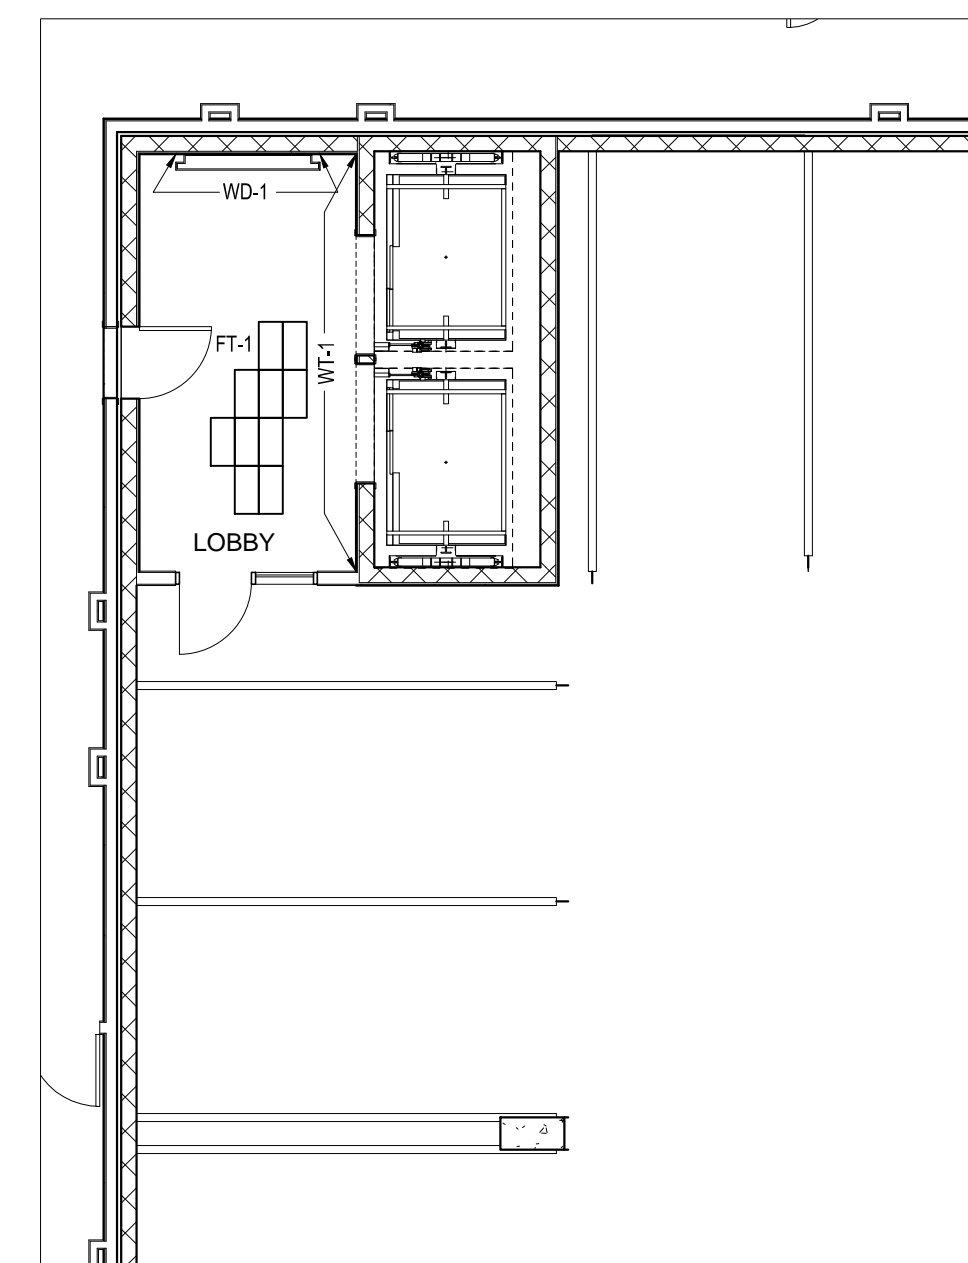


NW ELEV.
SCALE: 1/8" = 1'-0"

LEVEL 3

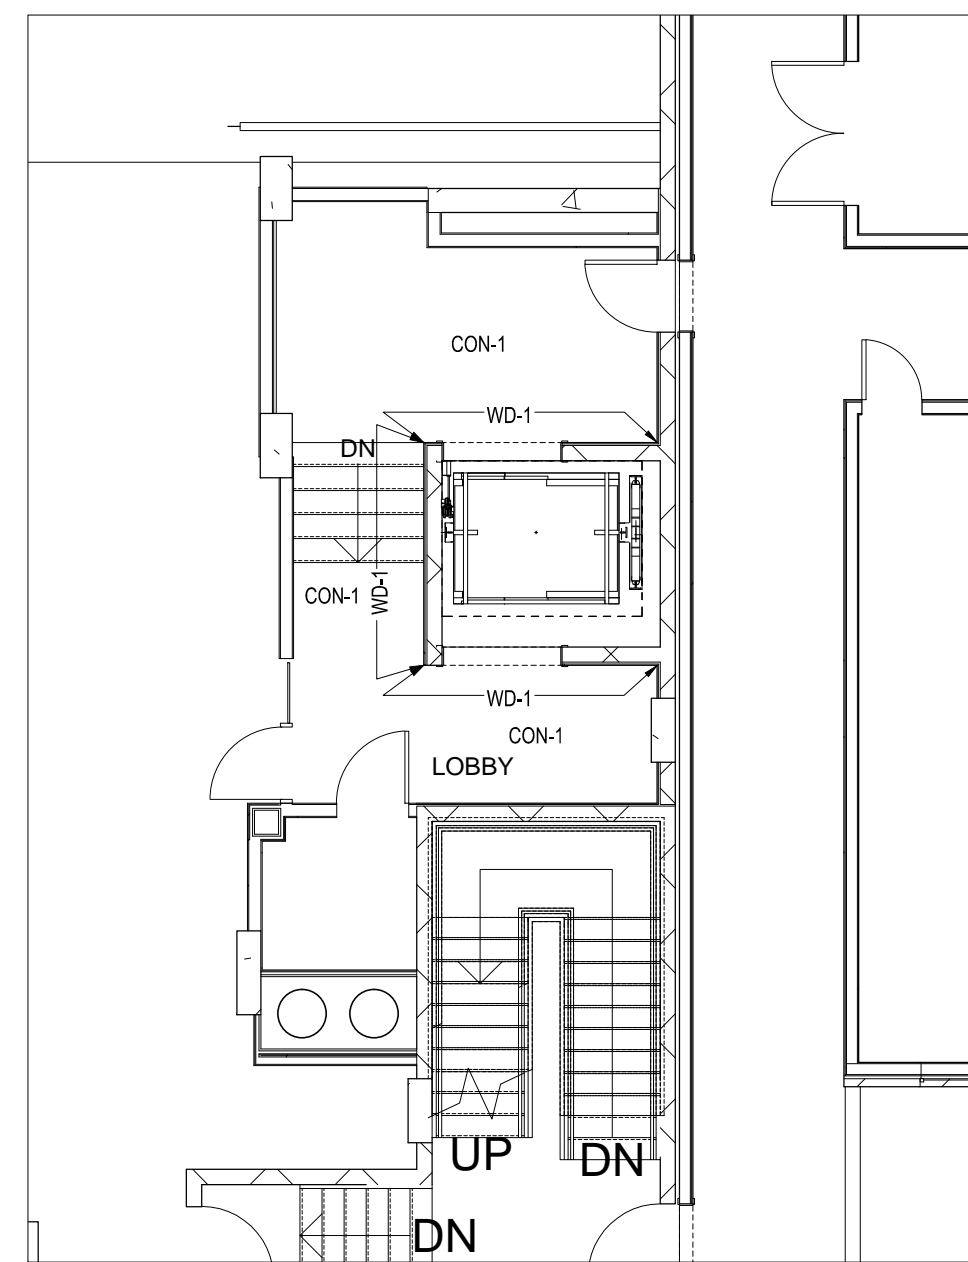


SE ELEV.
SCALE: 1/8" = 1'-0"

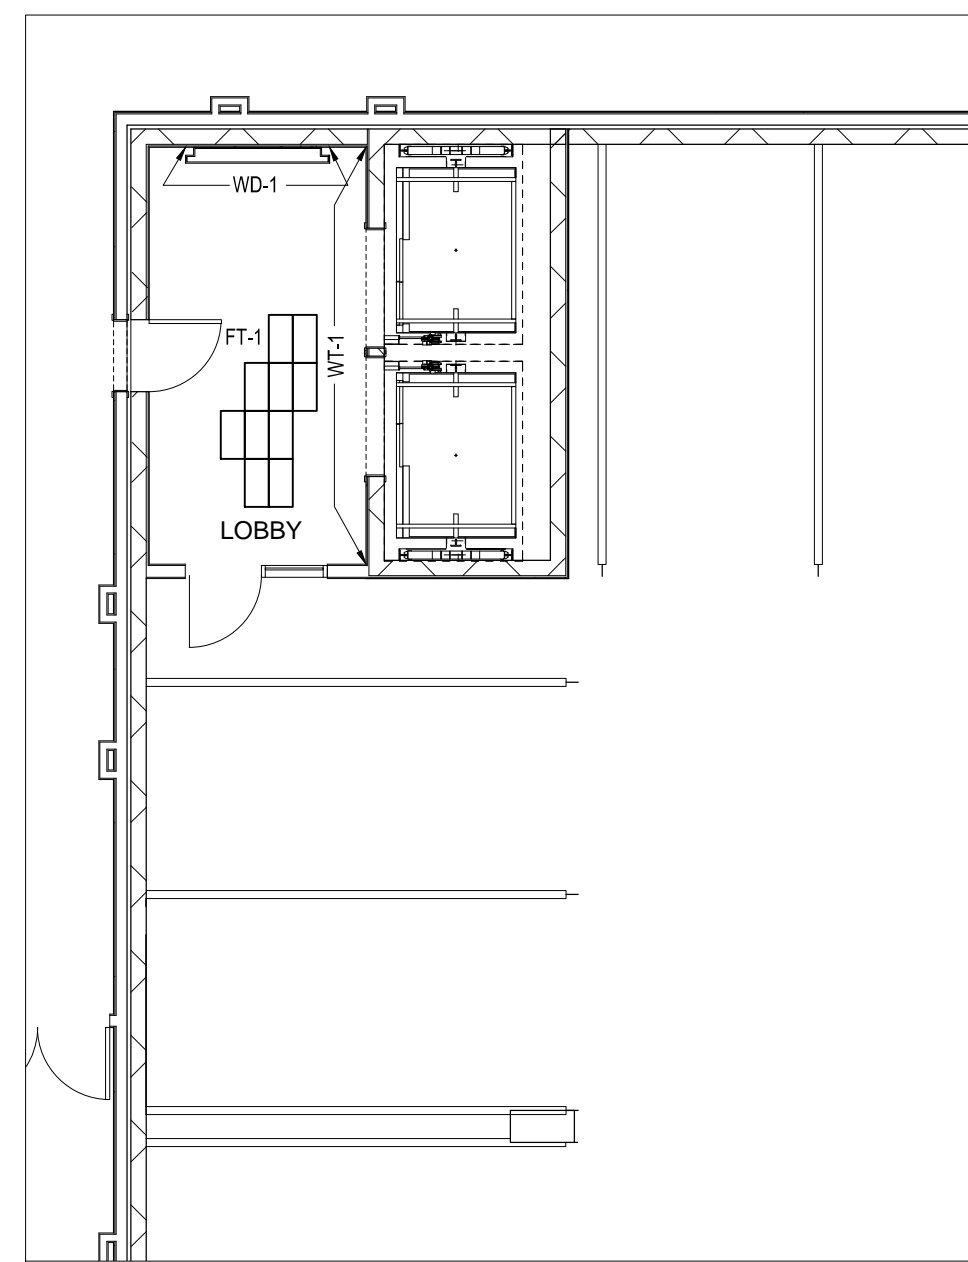


NW ELEV.
SCALE: 1/8" = 1'-0"

LEVEL 2

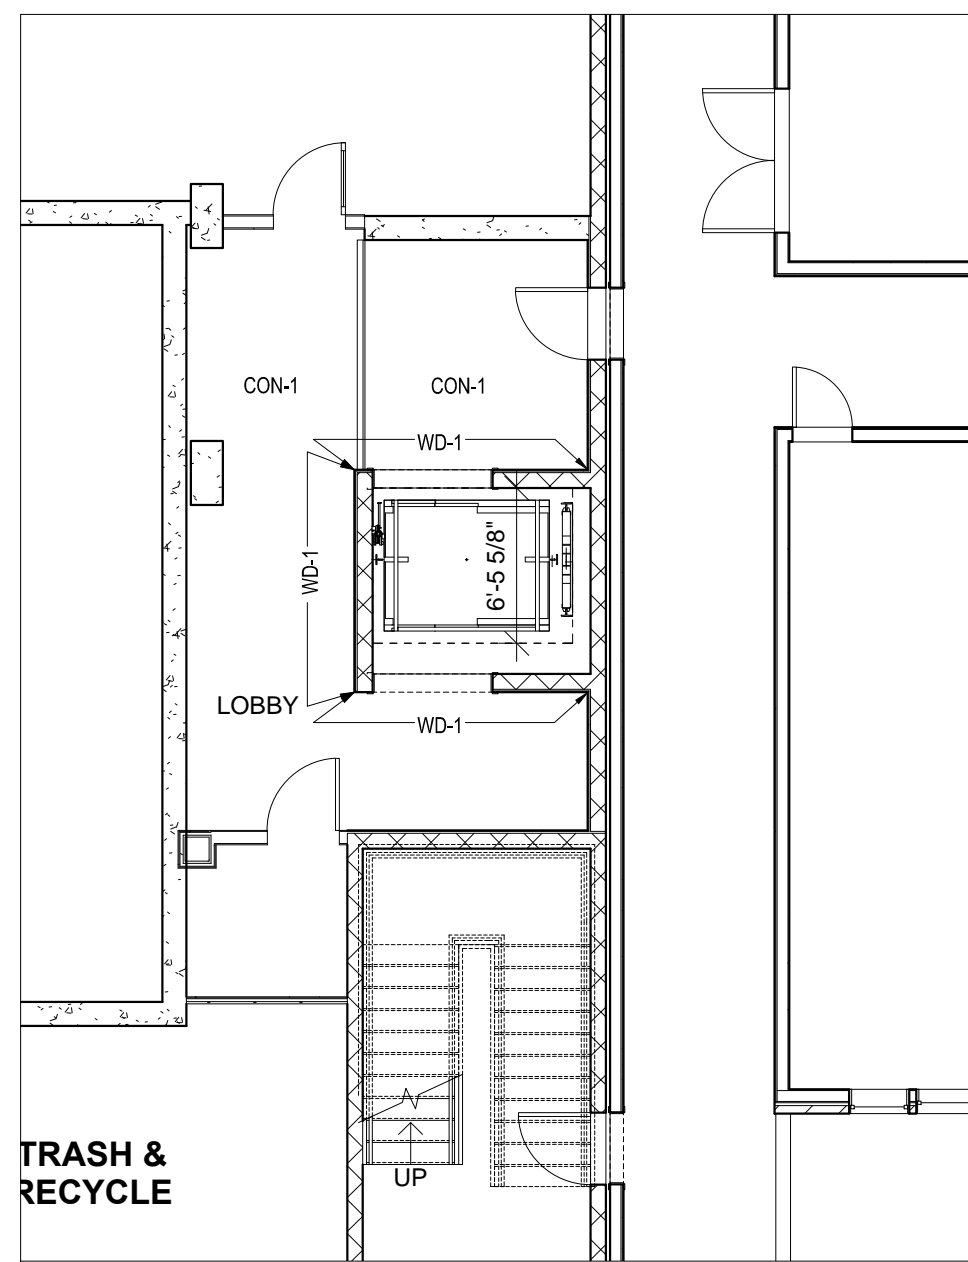


SE ELEV.
SCALE: 1/8" = 1'-0"

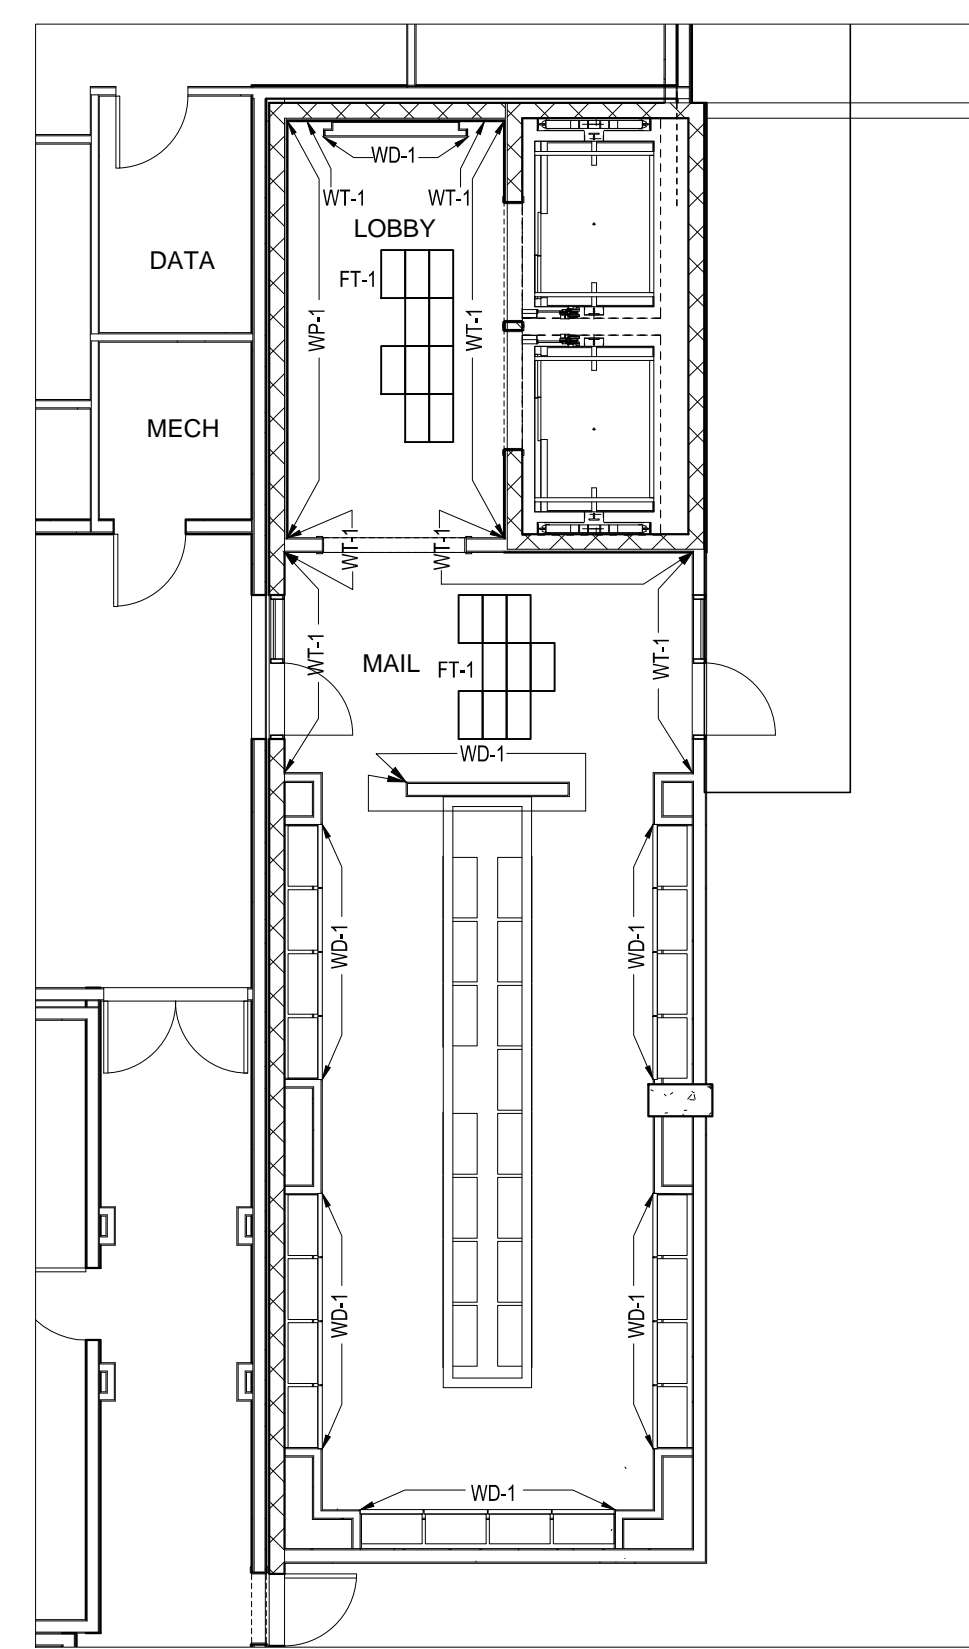

NW ELEV./ MAIL ROOM
SCALE: 1/8" = 1'-0"

LEVEL 1

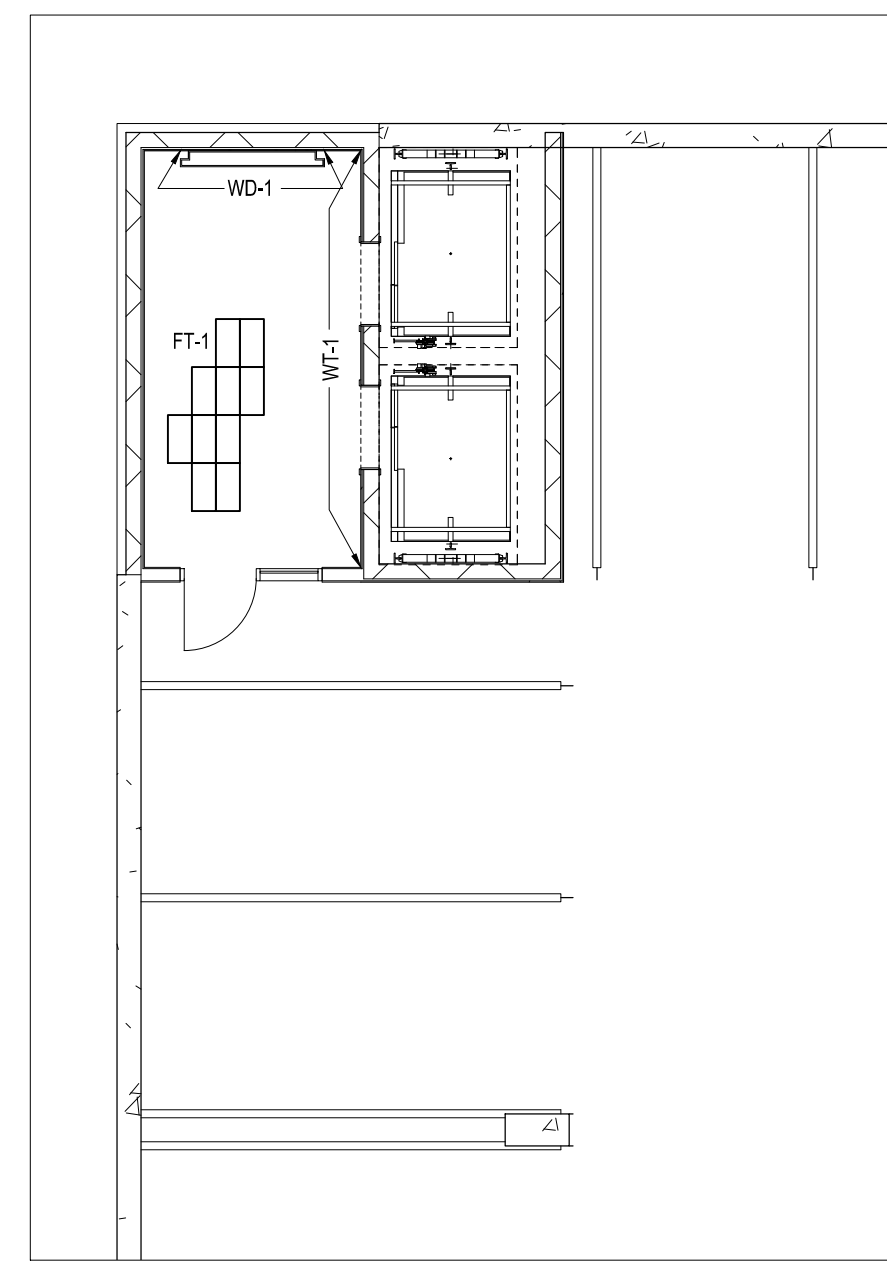

NW ELEV.
SCALE: 1/8" = 1'-0"

SUB LEVEL

PLEASANT VALLEY APARTMENTS
AUSTIN, TEXAS



GARAGE ELEVATORS
FINISH PLAN
SUB LEVEL
&
LEVEL 1-3

ID1.0

drawn by:
L. Wiggins
 checked by:
J. Paulson
 Date:
 04.16.2015 PERMIT

FOR:
 GARAGE PERMIT
 SCALE: AS NOTED


PLEASANT VALLEY APARTMENTS
 AUSTIN, TEXAS




GARAGE ELEVATORS
 FINISH PLAN
 LEVEL 4-6

ID1.1

FINISH SCHEDULE					
TAG	Description	Manufacturer	Product	Color/ Finish/ Size	Installation
Floors					
FT-1	Porcelain Floor Tile	Imola Ceramica	Koshi	Koshi CE/ 12" x 24"	Straight Lay
CON-1	Sealed Concrete				
Walls					
WT-1	Porcelain Wall Tile	Stone Source	Inessence	53K51R Miscela Sabbia/ 5-7/8" x 47-1/4"	Straight Lay
WD-1	Stained Wood Wall Planks			Stained to match Designer Sample	
WP-1	Fiberglass Panel	Modular Arts	Crush- Interlocking Rock Panel	To be painted on site	
PT-1	Paint	TBD	TBD	Color: TBD/ Finish: Satine	Throughout, U.N.O.

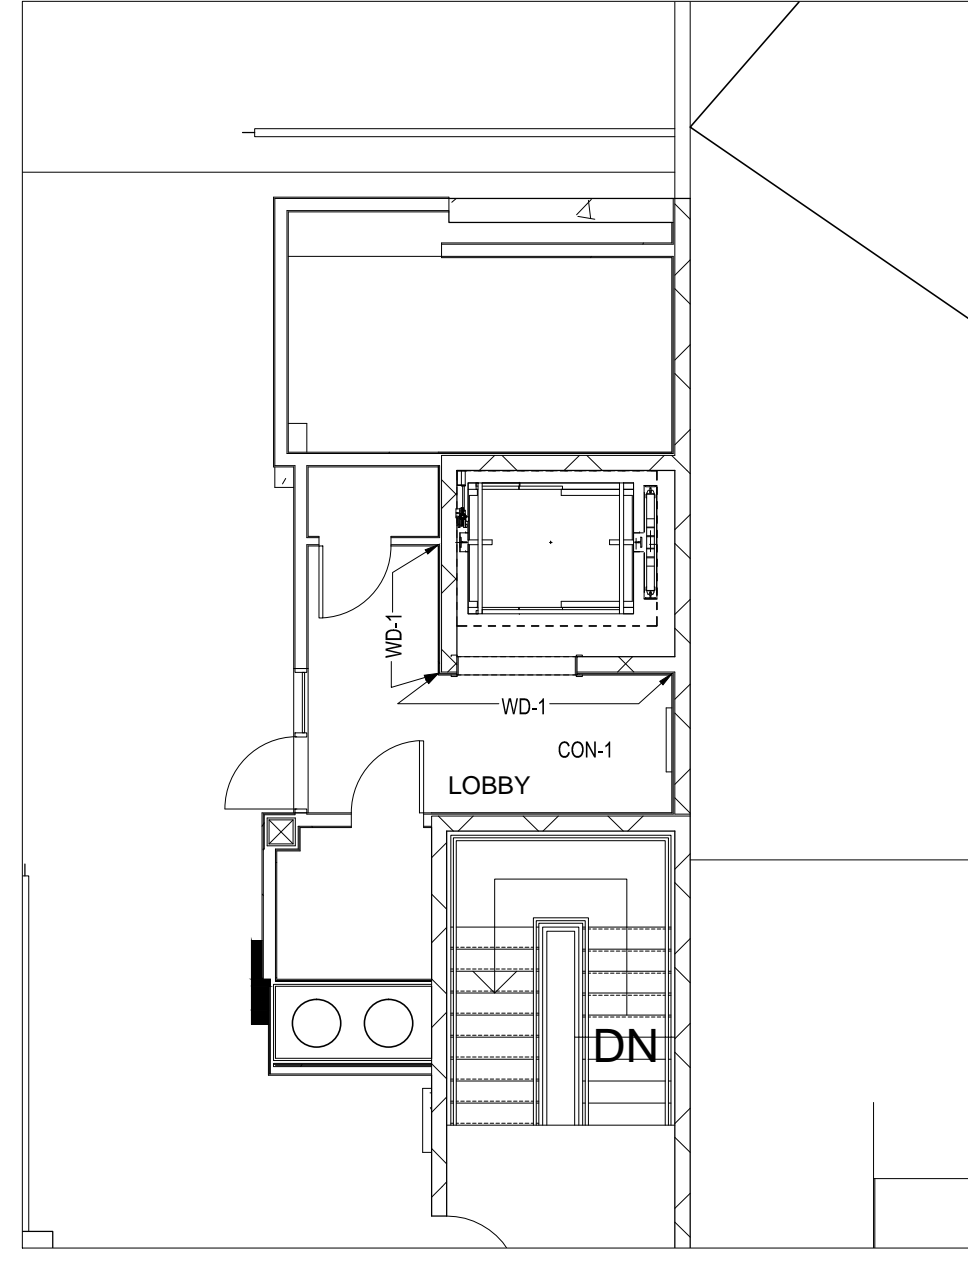


SE ELEV
 SCALE: 1/8" = 1'-0"

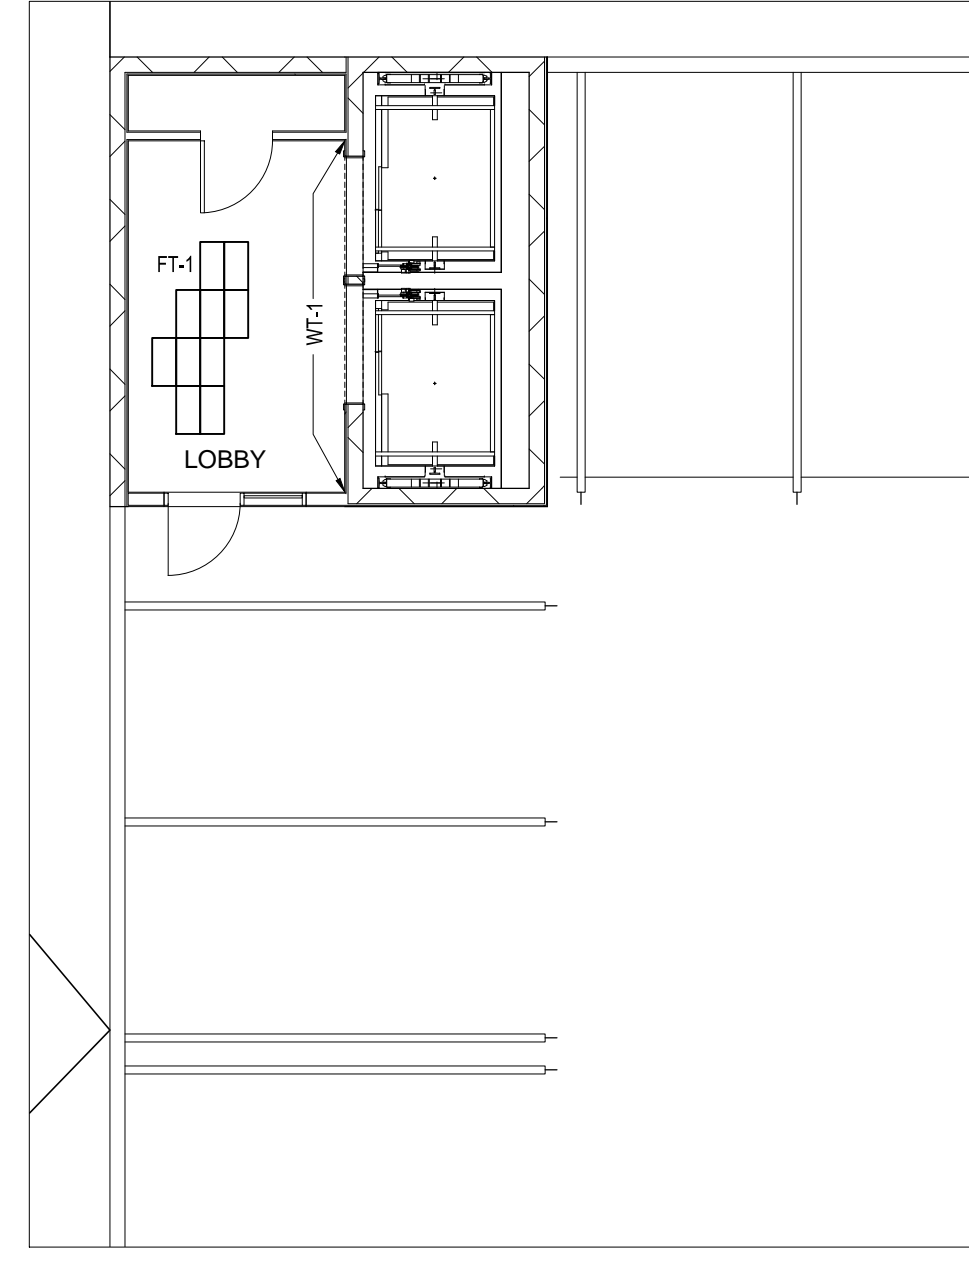


NW ELEV.
 SCALE: 1/8" = 1'-0"

LEVEL 6

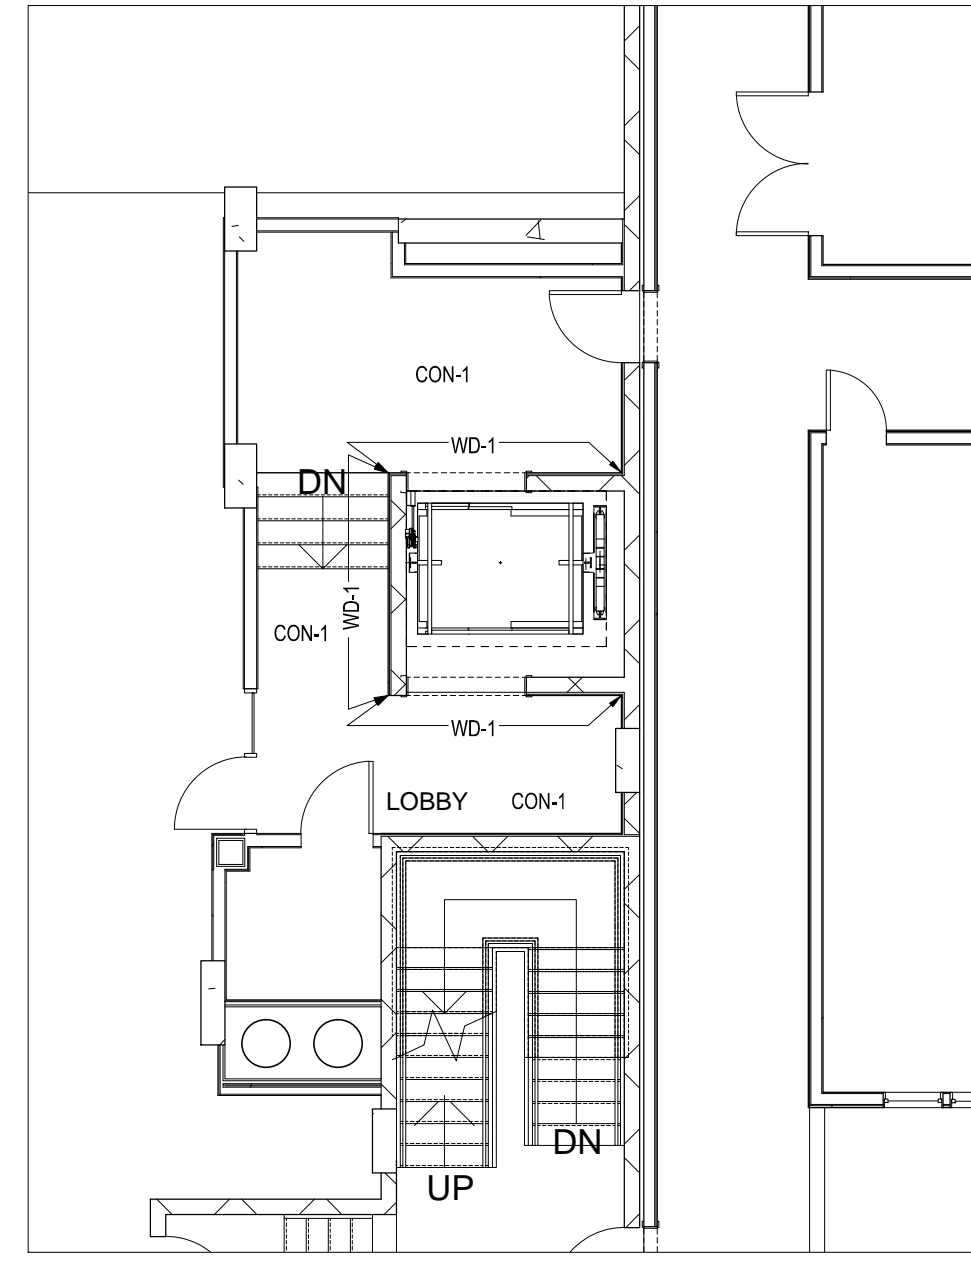


SE ELEV.
 SCALE: 1/8" = 1'-0"

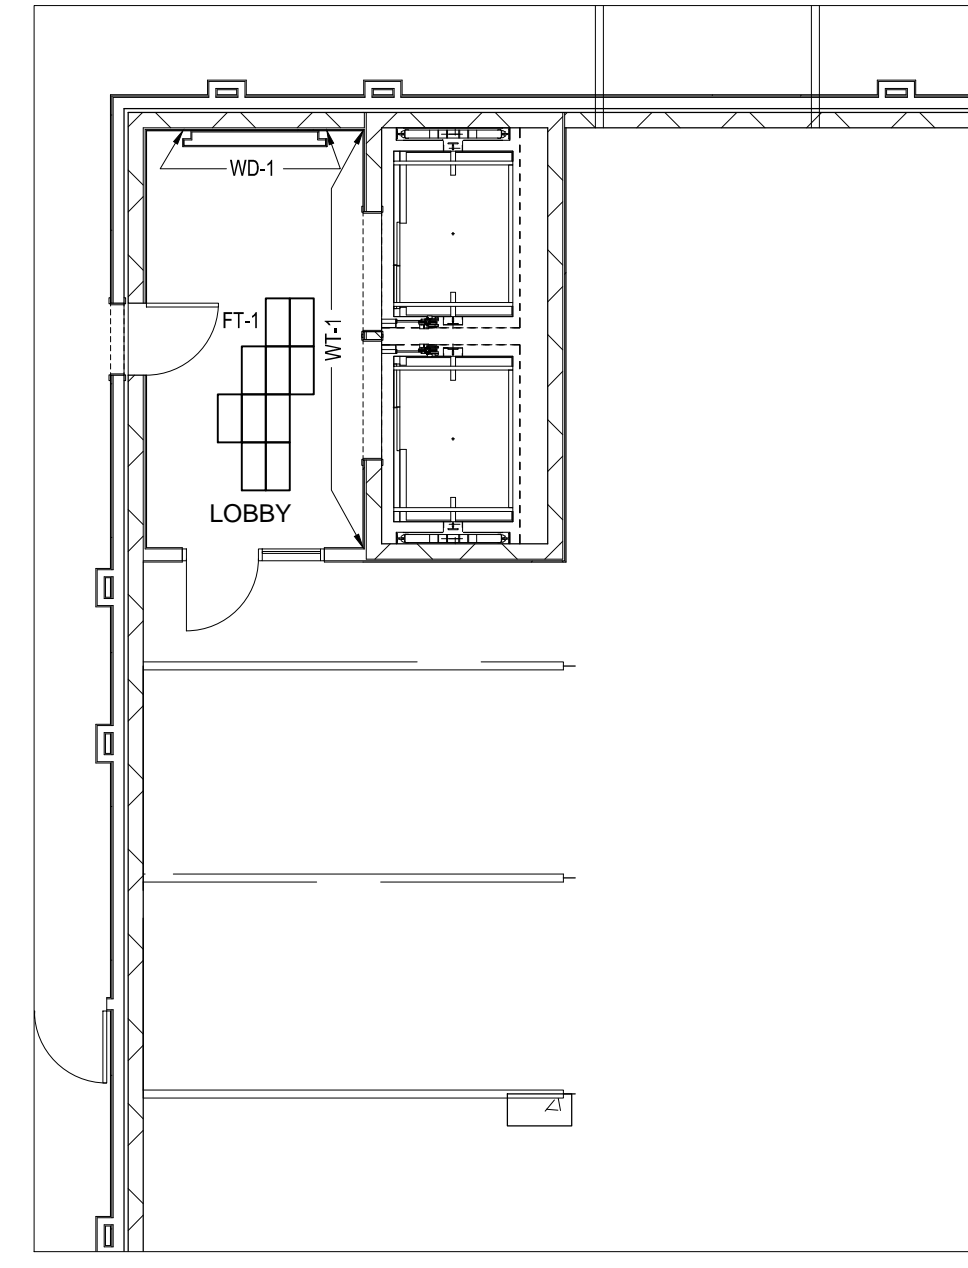


NW ELEV.
 SCALE: 1/8" = 1'-0"

LEVEL 5

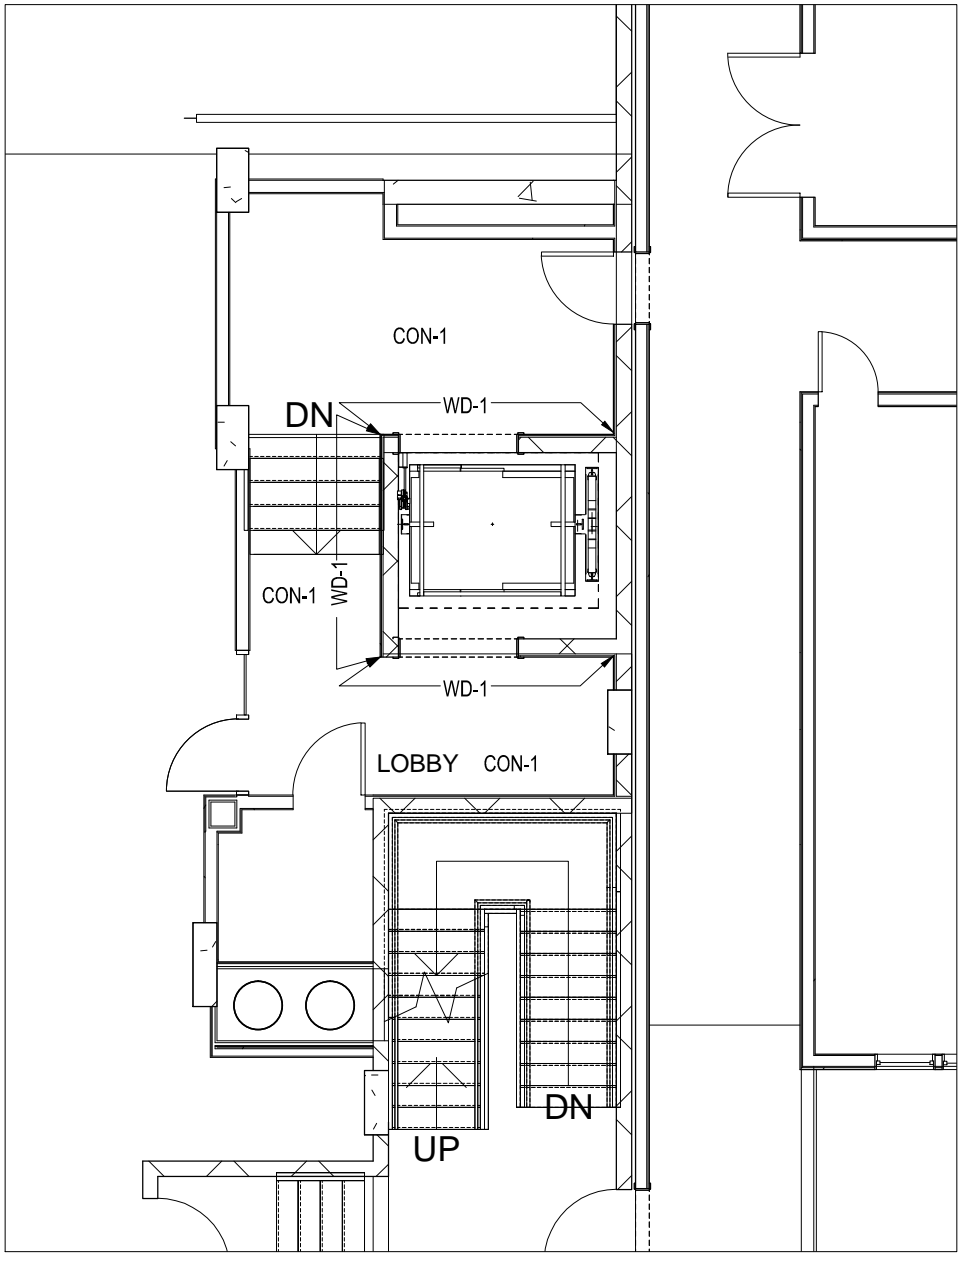

SE ELEV.
 SCALE: 1/8" = 1'-0"

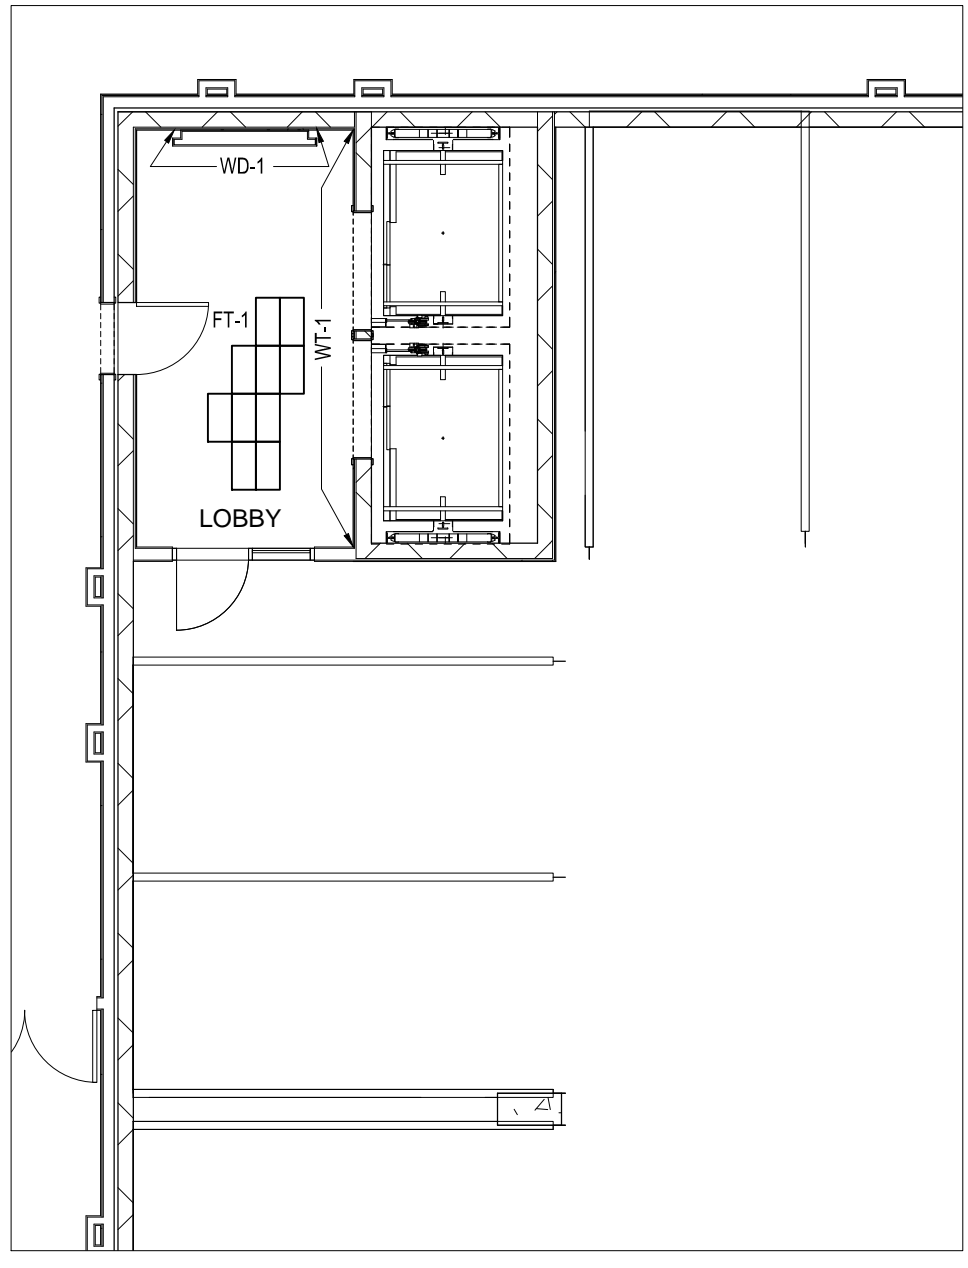

NW ELEV.
 SCALE: 1/8" = 1'-0"

LEVEL 4


drawn by:
L. Wiggins

checked by:
J. Paulson


Date:
04.16.2015 PERMIT

FOR:
GARAGE PERMIT
SCALE: AS NOTED

LIGHTING SCHEDULE					
Symbol	Description	Manufacturer	Product	Lamp	Finish
DF-1	Wall Sconce	Sonneman	Stiletto 32 Dimmable LED Sconce (2342.25-DIM)/ 31.75"H x 5"W x 3.25" Ext.	LED 11W	Satin Black/ Frosted Acrylic
DF-2	Pendant Light	Nuevo Living	Apollo Pendant (HGVF271)/ 19.75"W x 17"D x 21.25"H/ cord length 27.75"	(1) 60 watt bulb	Black Metal Shade/ Canopy
DF-3	Surface Mount Light	Louis Poulsen	LP Circle Surface/ 18"Dia x 5.5"H	LED 30W 3500K	Black
DF-4	Floor Uplight	Zaneen	Alcor 2W Monochromatic/ALC.028.28.US	LED 3000K	Satin Stainless Steel
DF-5	Cove Lighting	Tivoli Lighting	Platinum Cove LED; Series 01; PTCL-01-U-32-12	LED 3200K	Black
DF-6	Recessed Downlight	TBD	6" Diameter recessed downlight	LED 3000K	White

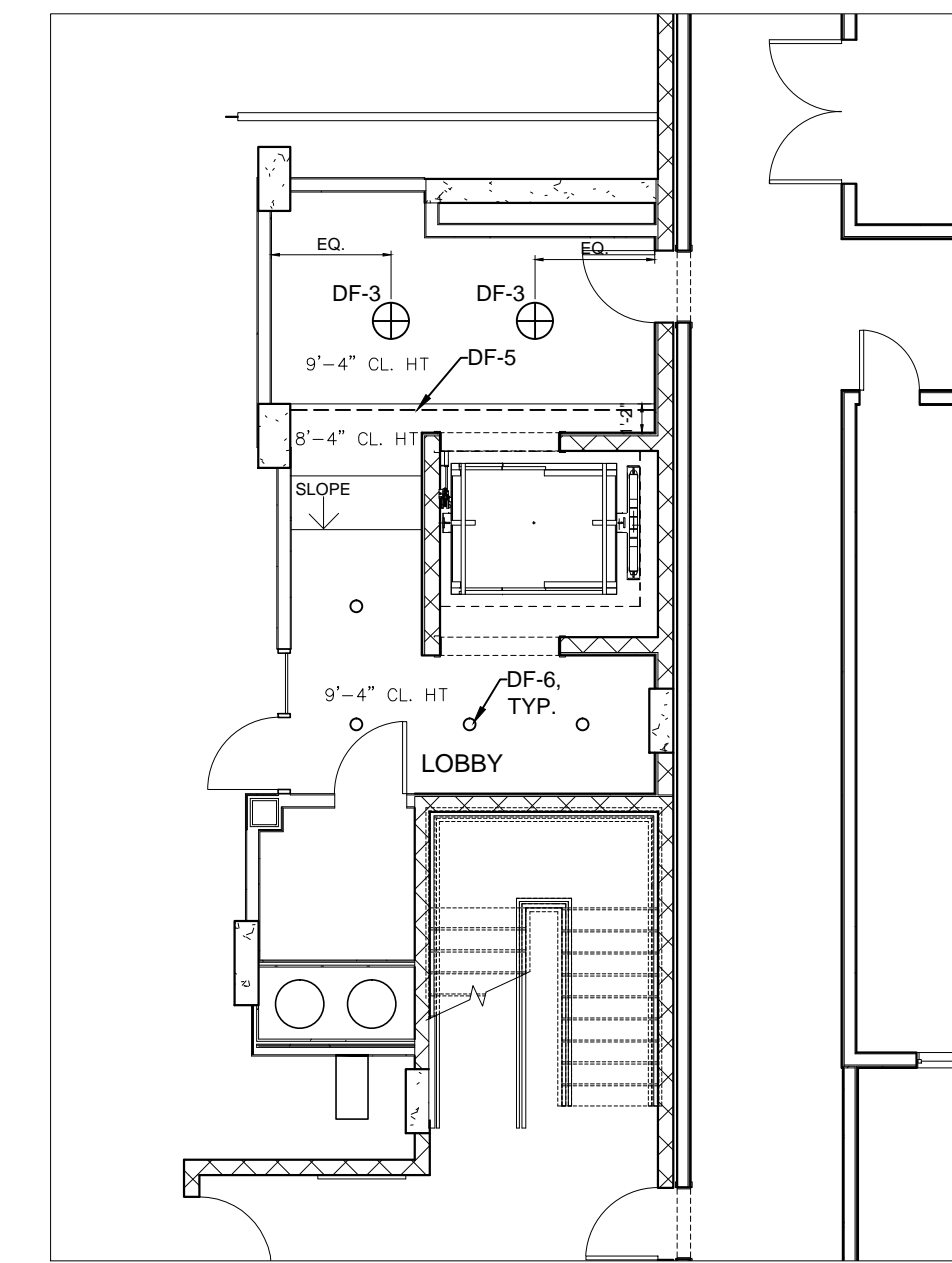


SE ELEV.
SCALE: 1/8" = 1'-0"

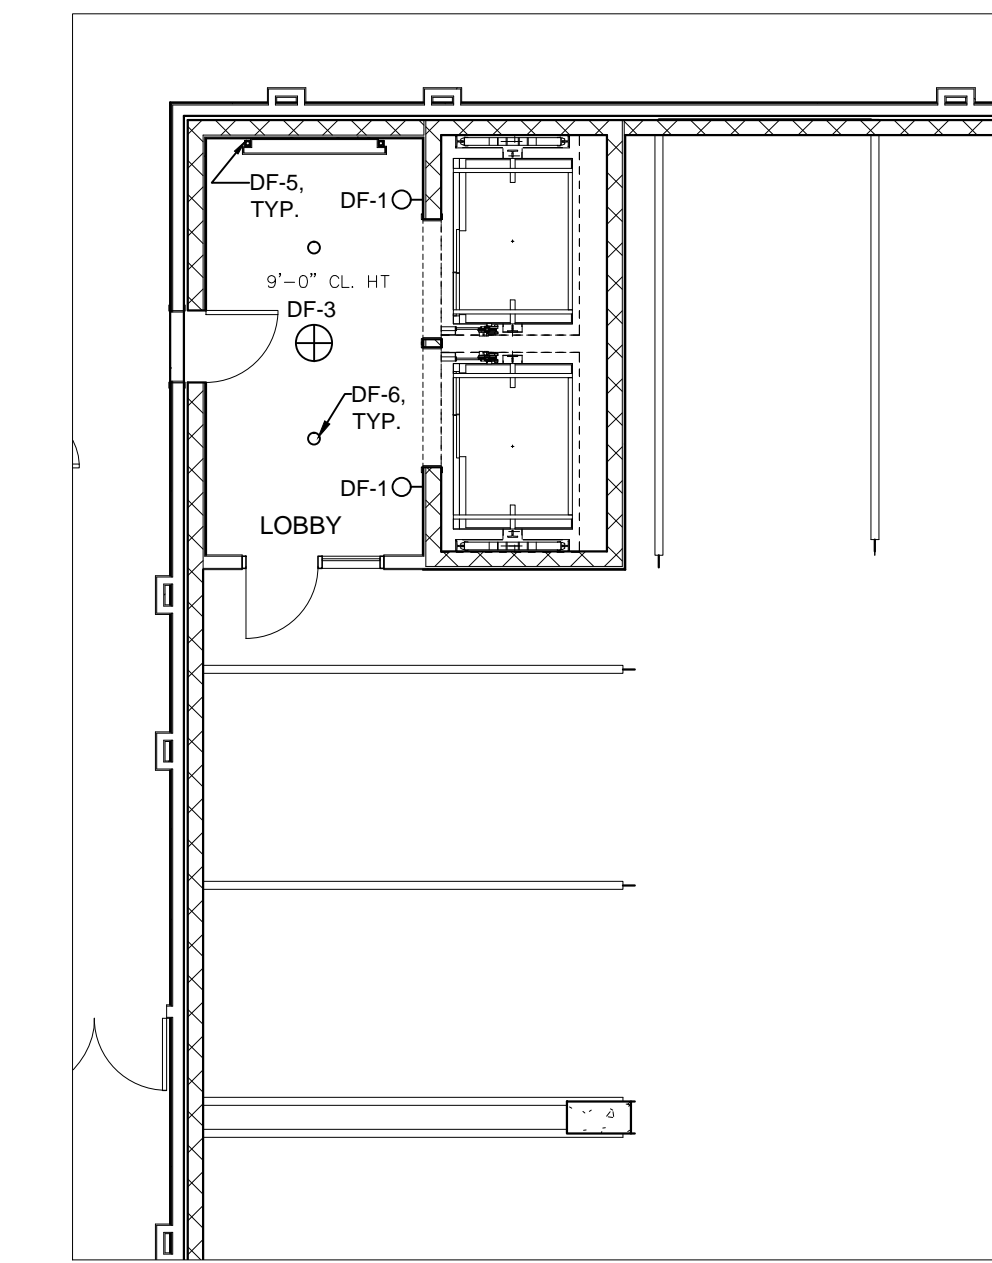


NW ELEV.
SCALE: 1/8" = 1'-0"

LEVEL 3

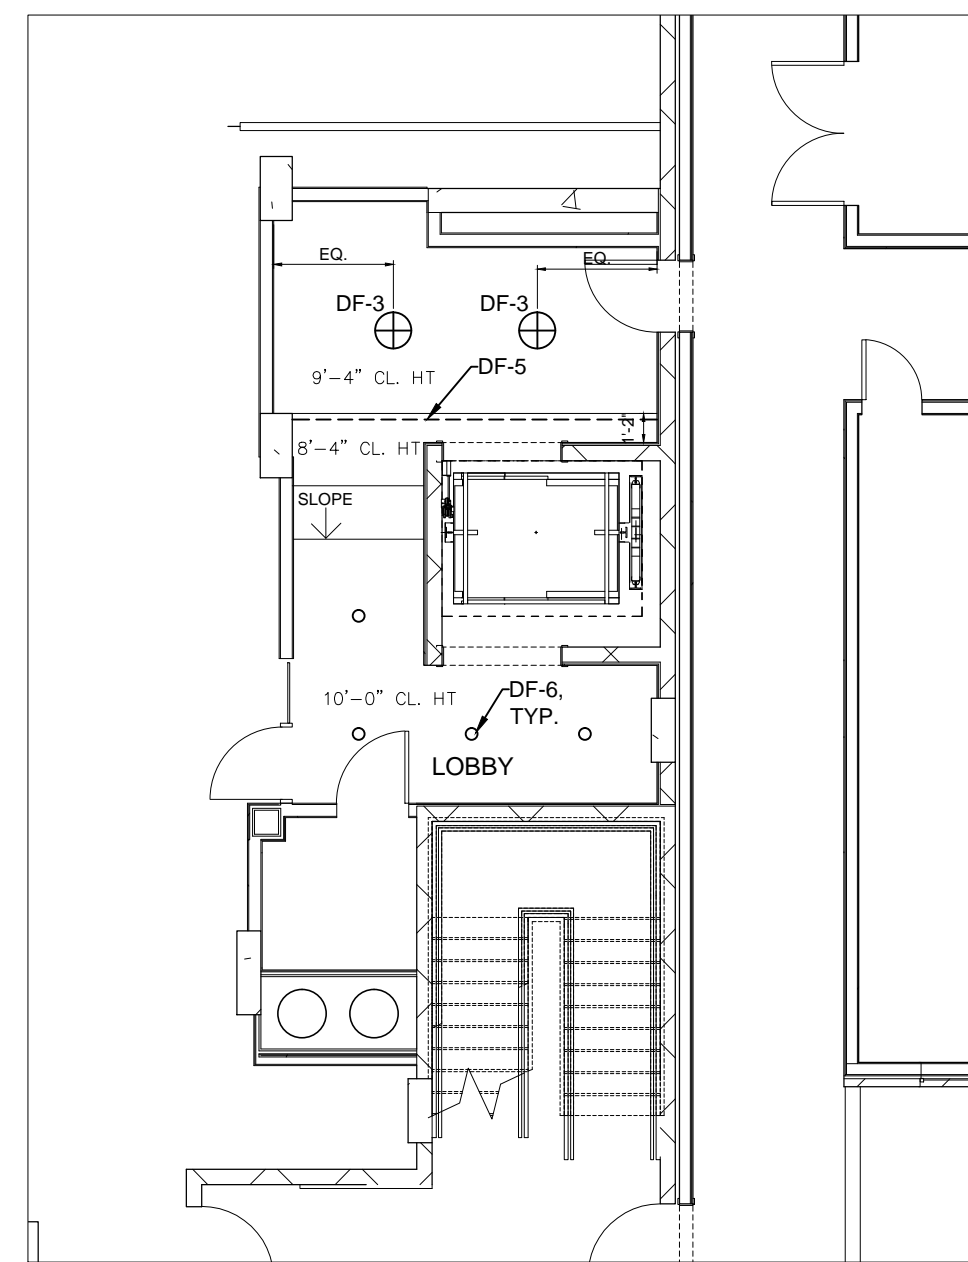


SE ELEV.
SCALE: 1/8" = 1'-0"

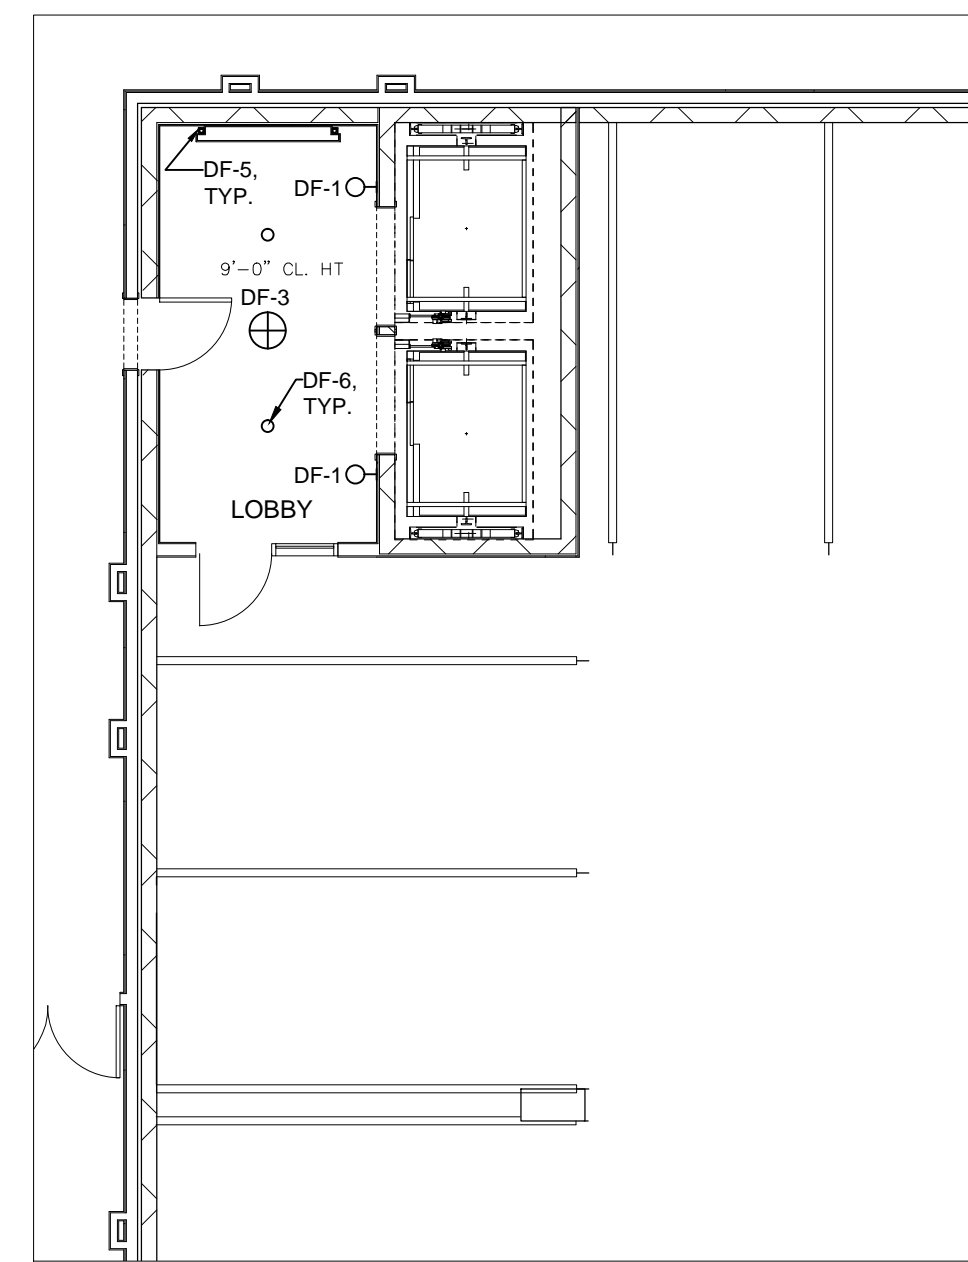


NW ELEV.
SCALE: 1/8" = 1'-0"

LEVEL 2

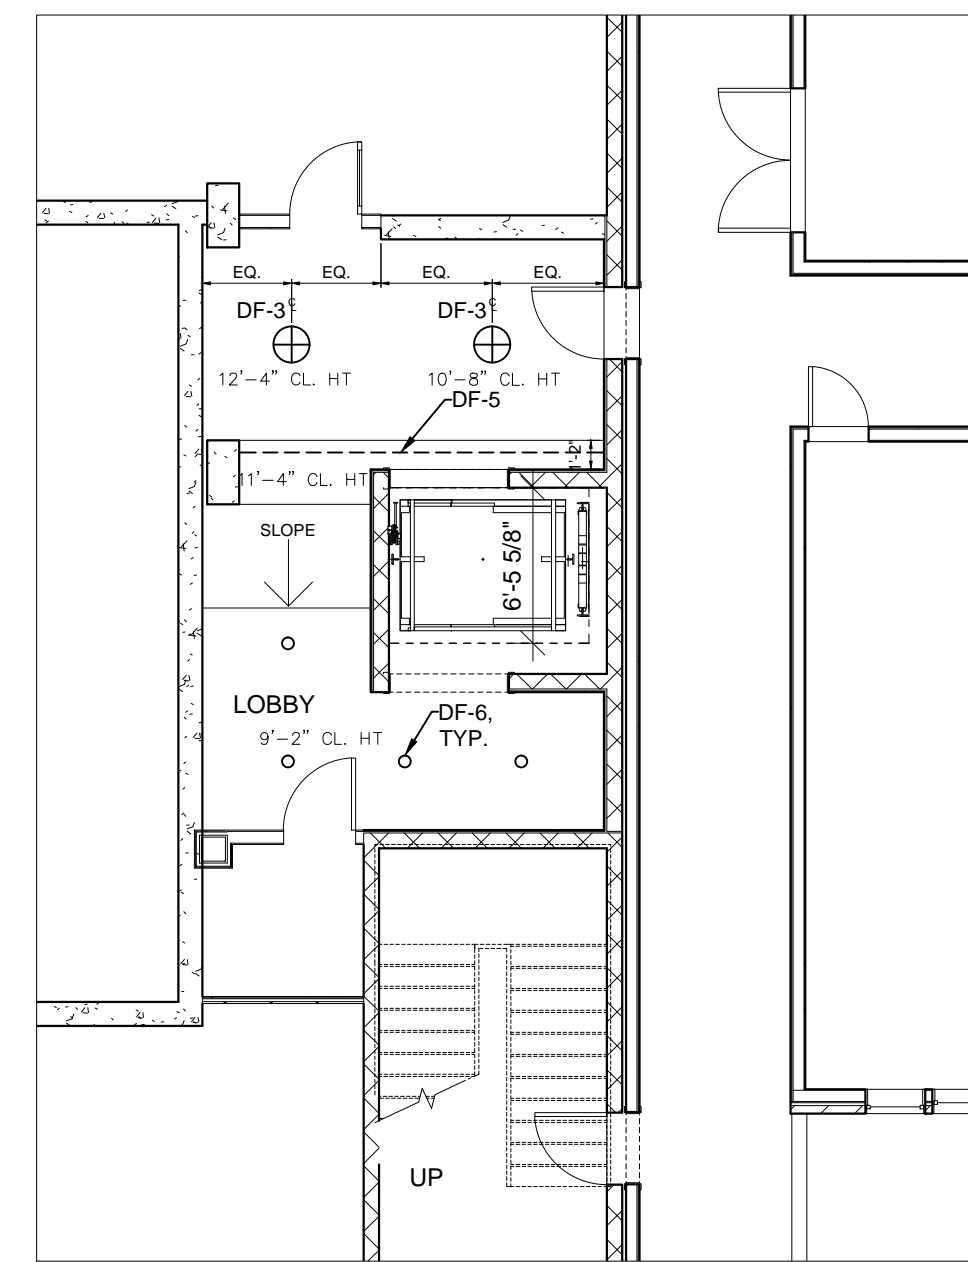


SE ELEV.
SCALE: 1/8" = 1'-0"

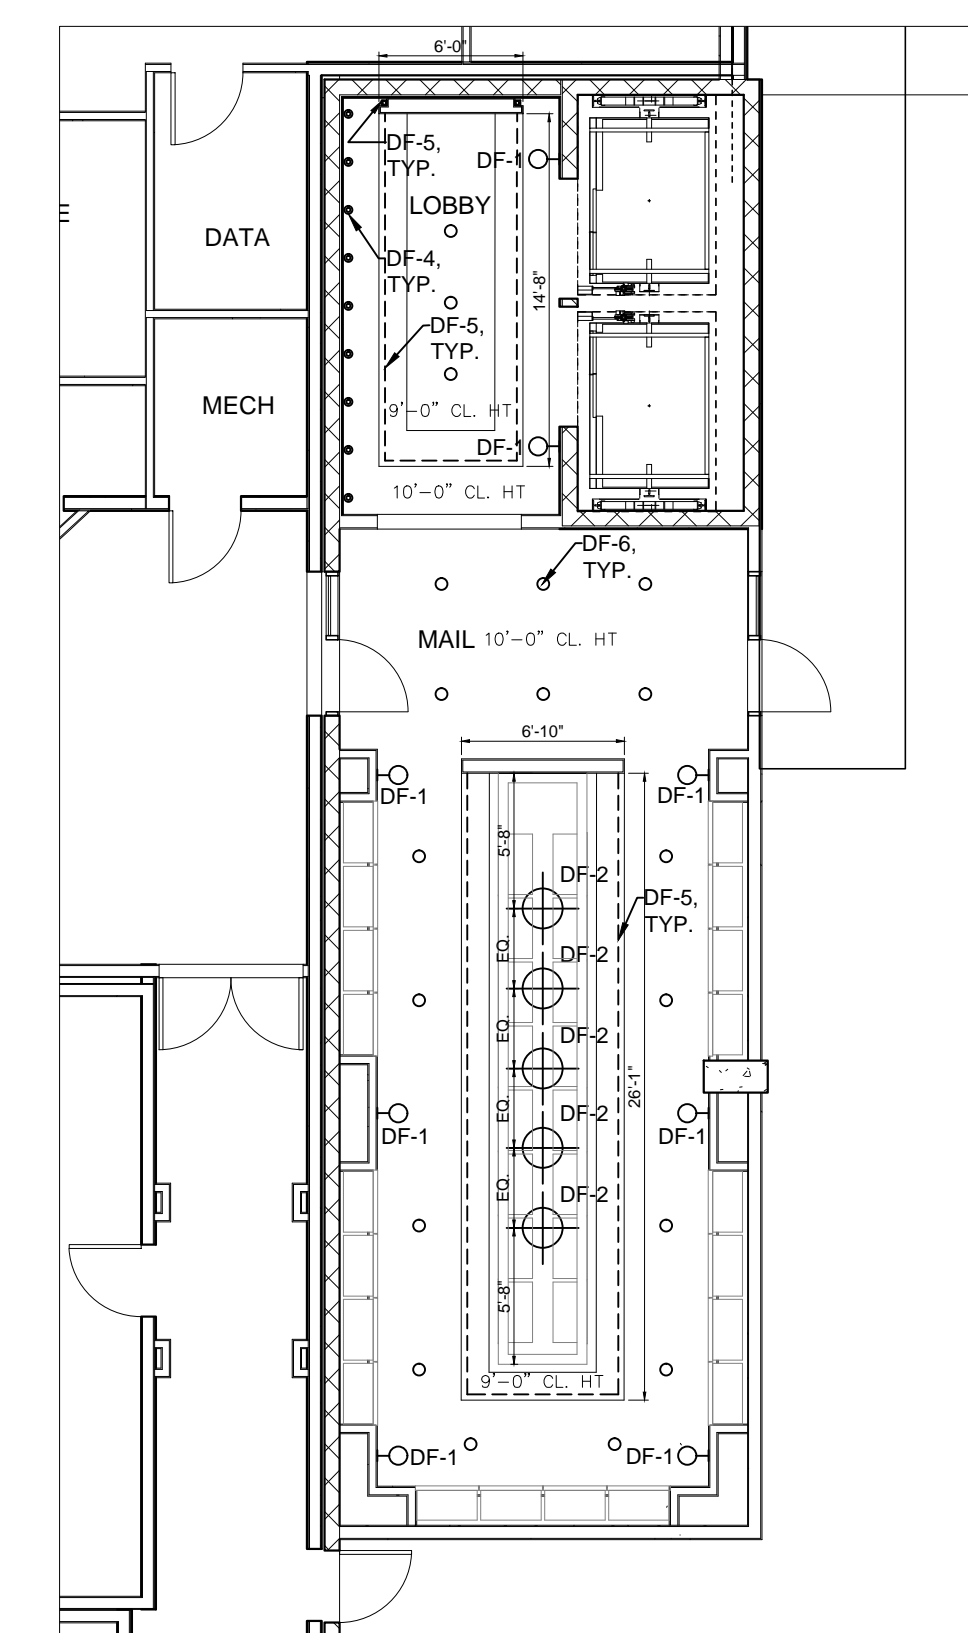

NW ELEV./ MAIL ROOM
SCALE: 1/8" = 1'-0"


LEVEL 1

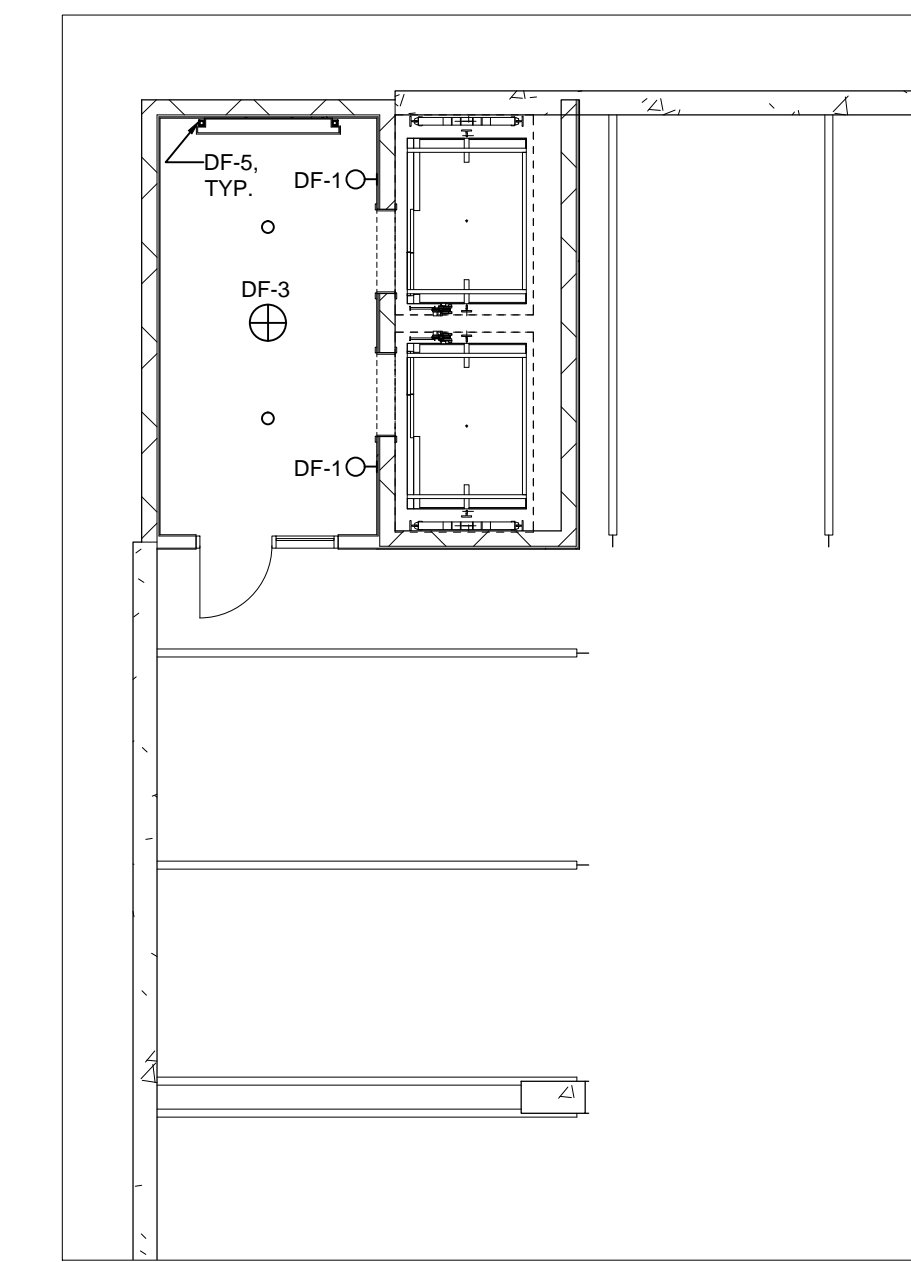

NW ELEV.
SCALE: 1/8" = 1'-0"

SUB LEVEL

PLEASANT VALLEY APARTMENTS
AUSTIN, TEXAS

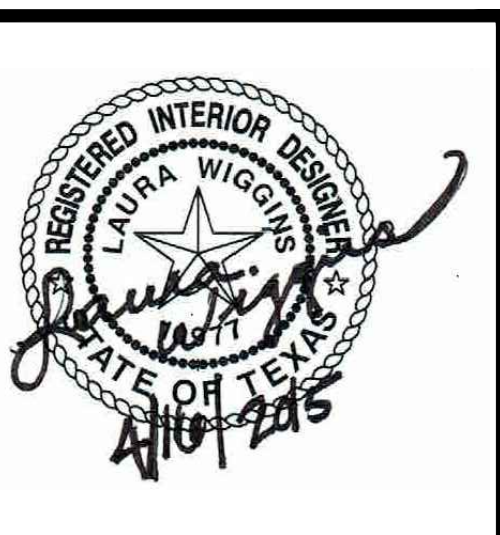

GARAGE ELEVATORS
LIGHTING PLAN
SUB LEVEL
&
LEVEL 1-3

ID2.0

drawn by:
L. Wiggins

checked by:
J. Paulson

Date:
04.16.2015 PERMIT

FOR:
GARAGE PERMIT
SCALE: AS NOTED


PLEASANT VALLEY APARTMENTS
AUSTIN, TEXAS




GARAGE ELEVATORS
LIGHTING PLAN
LEVEL 4-6

ID2.1

LIGHTING SCHEDULE					
Symbol	Description	Manufacturer	Product	Lamp	Finish
DF-1	Wall Sconce	Sonneman	Stiletto 32 Dimmable LED Sconce (2342.25-DIM)/ 31.75"H x 5"W x 3.25" Ext.	LED 11W	Satin Black/ Frosted Acrylic
DF-2	Pendant Light	Nuevo Living	Apollo Pendant (HGVF271)/ 19.75"W x 17"D x 21.25"H/ cord length 27.75"	(1) 60 watt bulb	Black Metal Shade/ Canopy
DF-3	Surface Mount Light	Louis Poulsen	LP Circle Surface/ 18"Dia x 5.5"H	LED 30W 3500K	Black
DF-4	Floor Uplight	Zaneen	Alcor 2W Monochromatic/ALC.028.28.US	LED 3000K	Satin Stainless Steel
DF-5	Cove Lighting	Tivoli Lighting	Platinum Cove LED; Series 01; PTCL-01-U-32-12	LED 3200K	Black
DF-6	Recessed Downlight	TBD	6" Diameter recessed downlight	LED 3000K	White

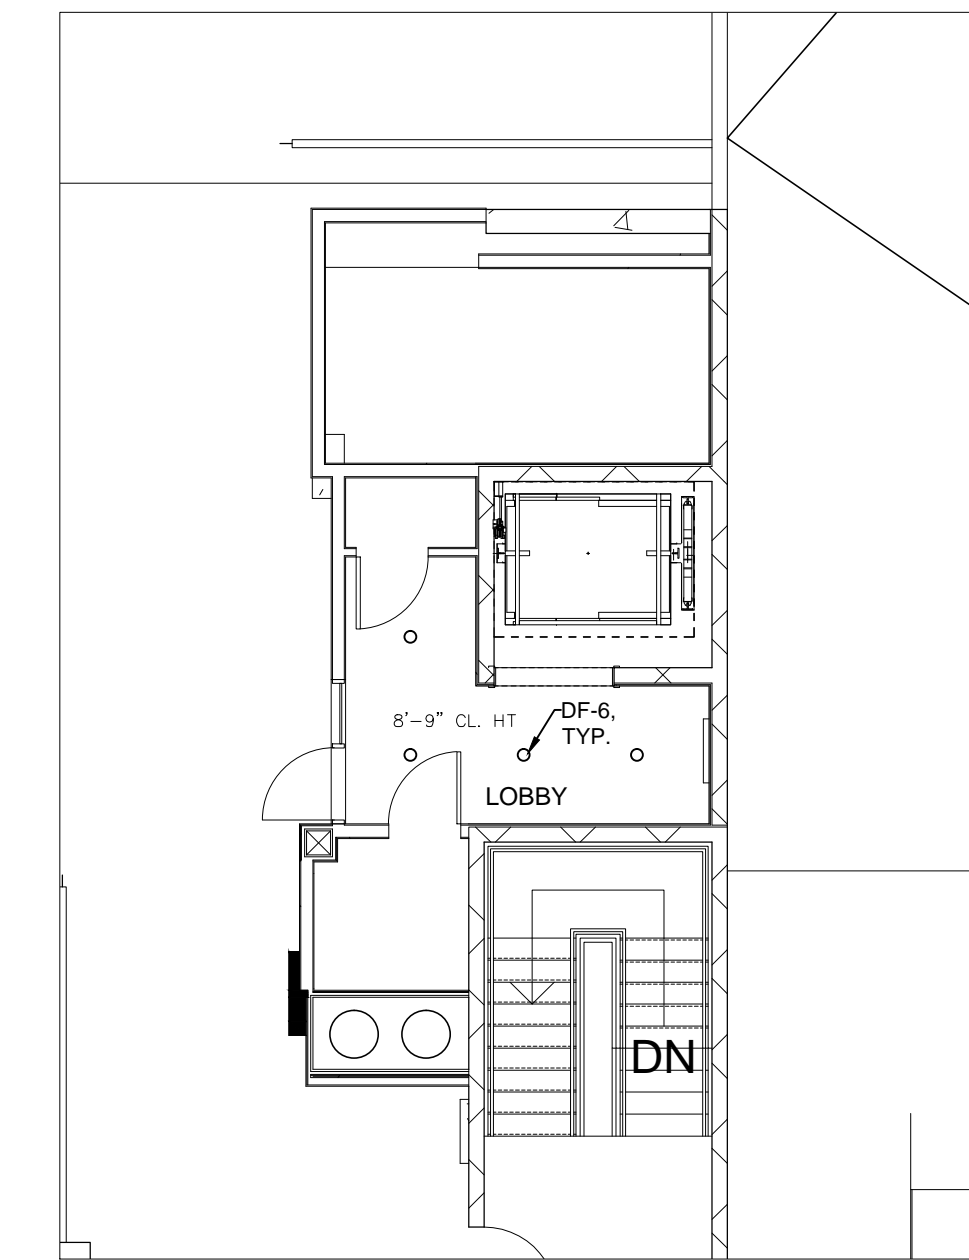


SE ELEV
SCALE: 1/8" = 1'-0"

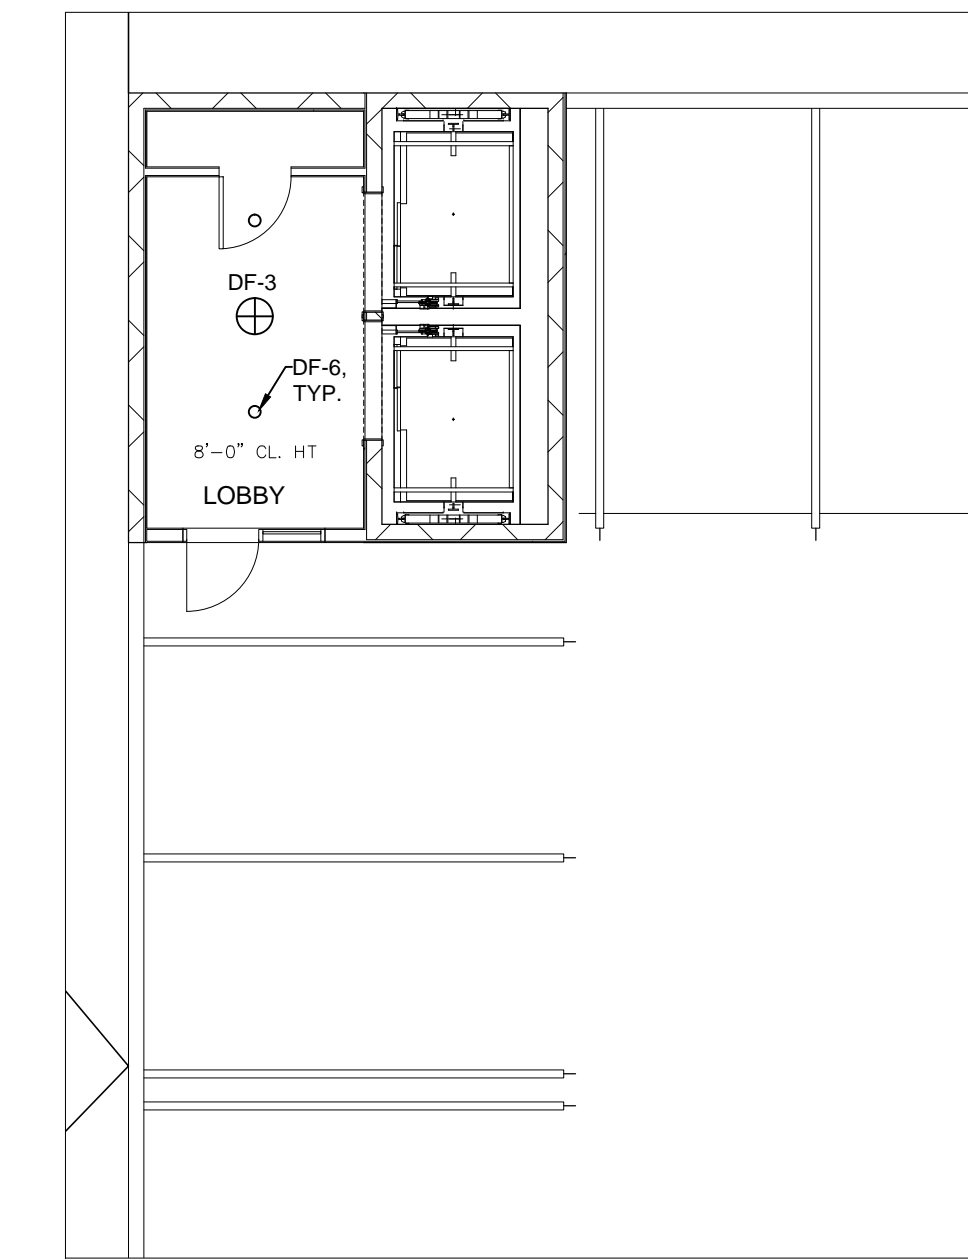


NW ELEV.
SCALE: 1/8" = 1'-0"

LEVEL 6

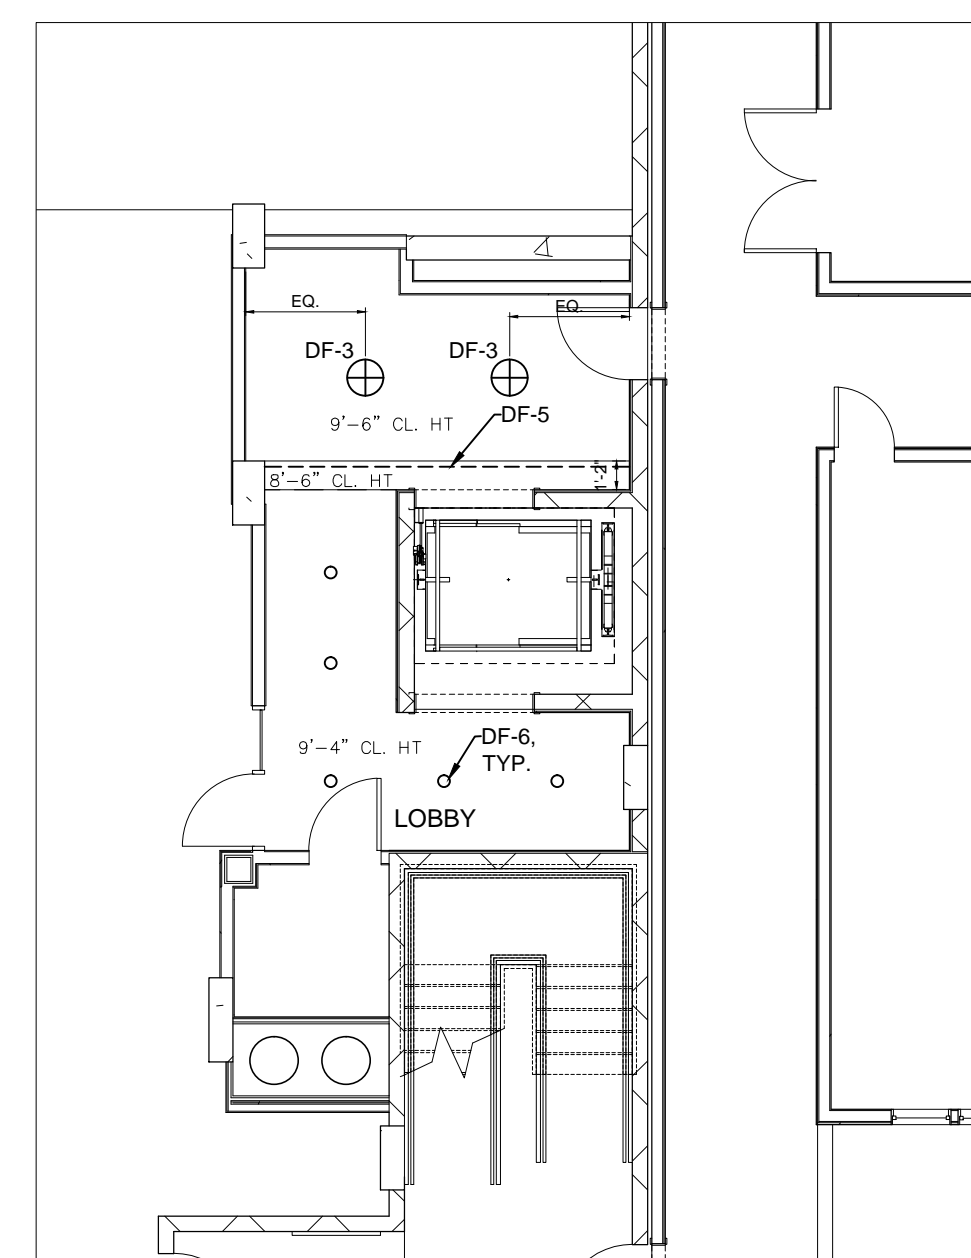


SE ELEV.
SCALE: 1/8" = 1'-0"

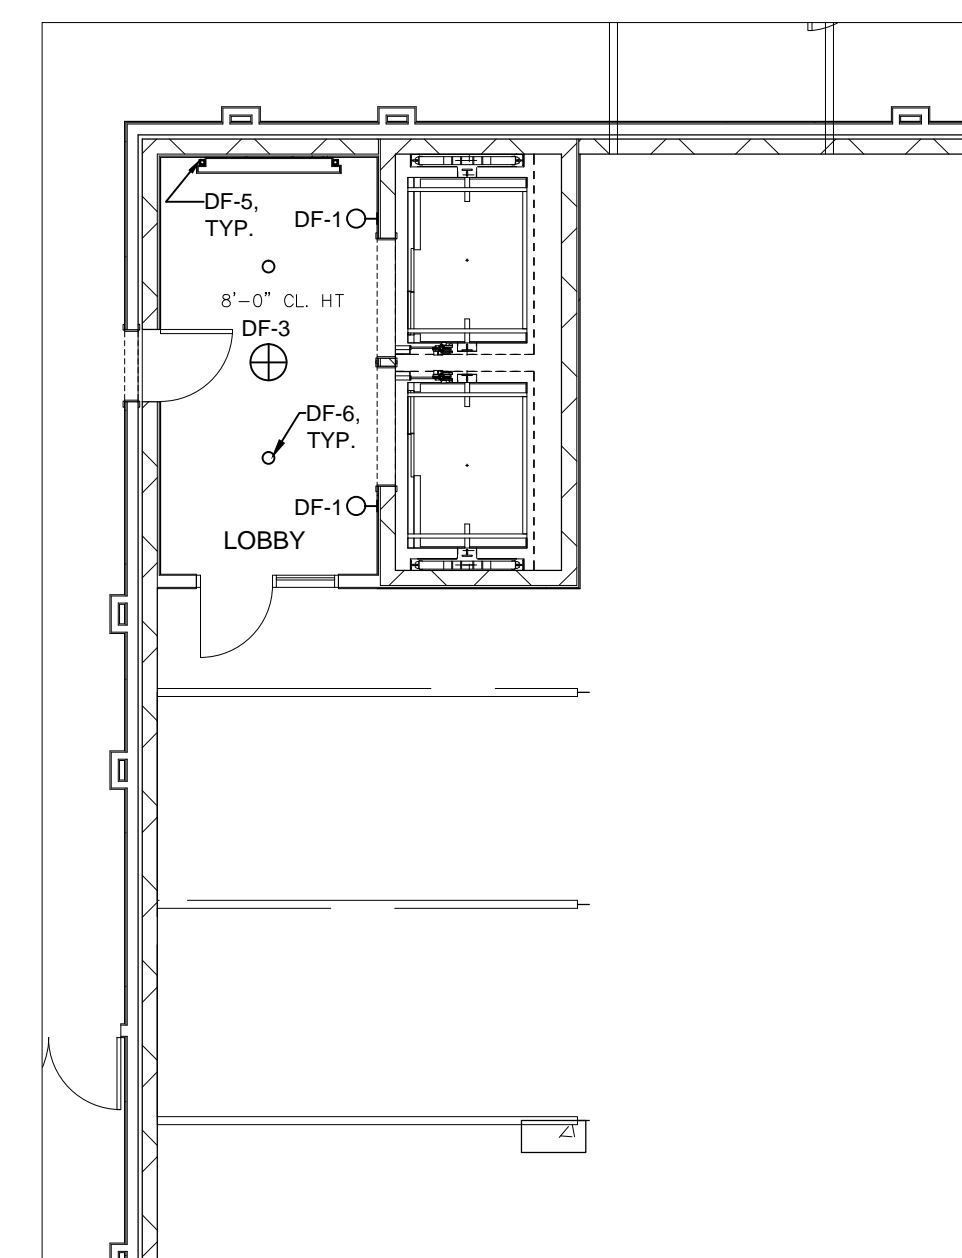


NW ELEV.
SCALE: 1/8" = 1'-0"

LEVEL 5

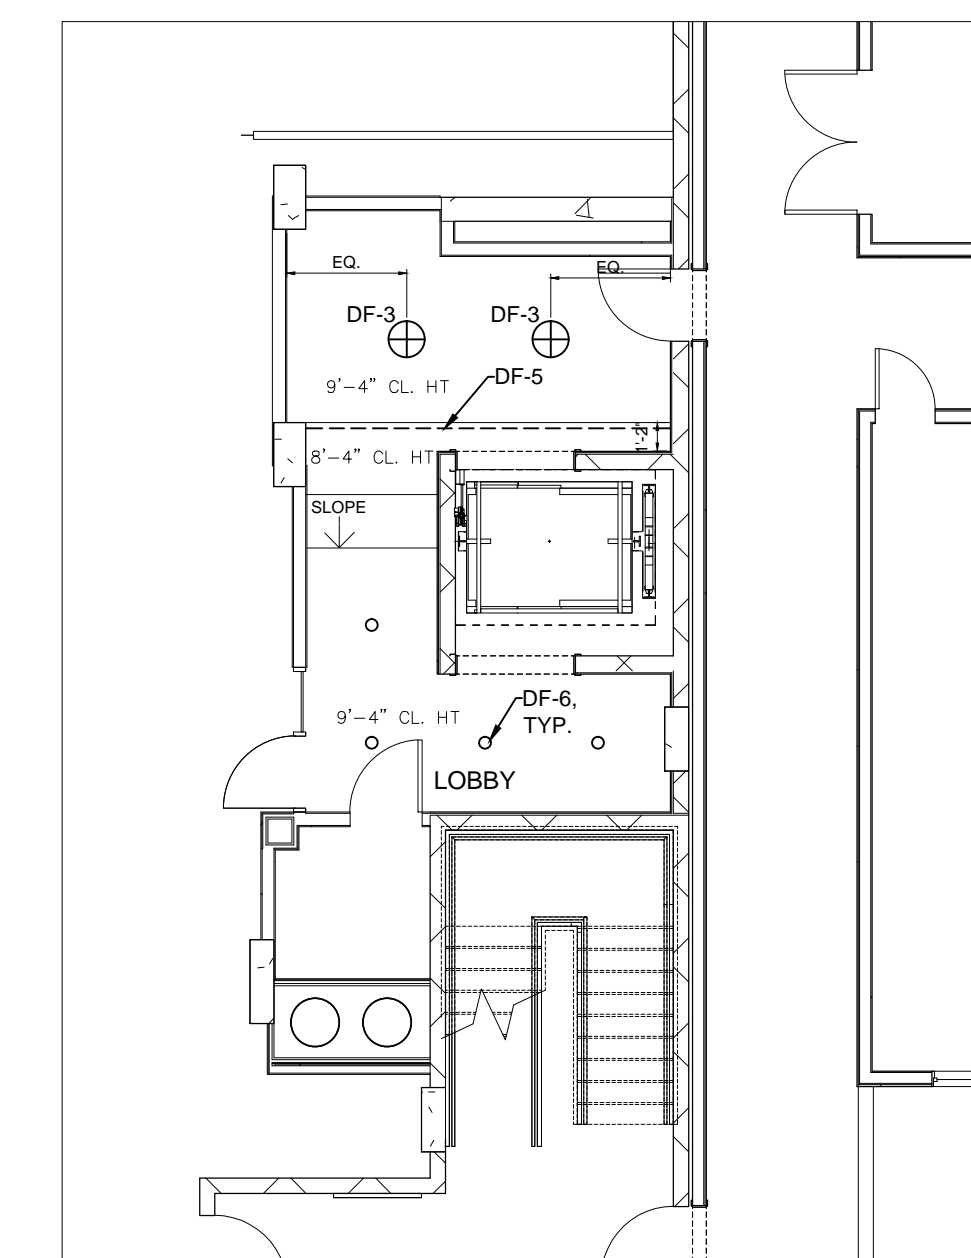

SE ELEV.
SCALE: 1/8" = 1'-0"

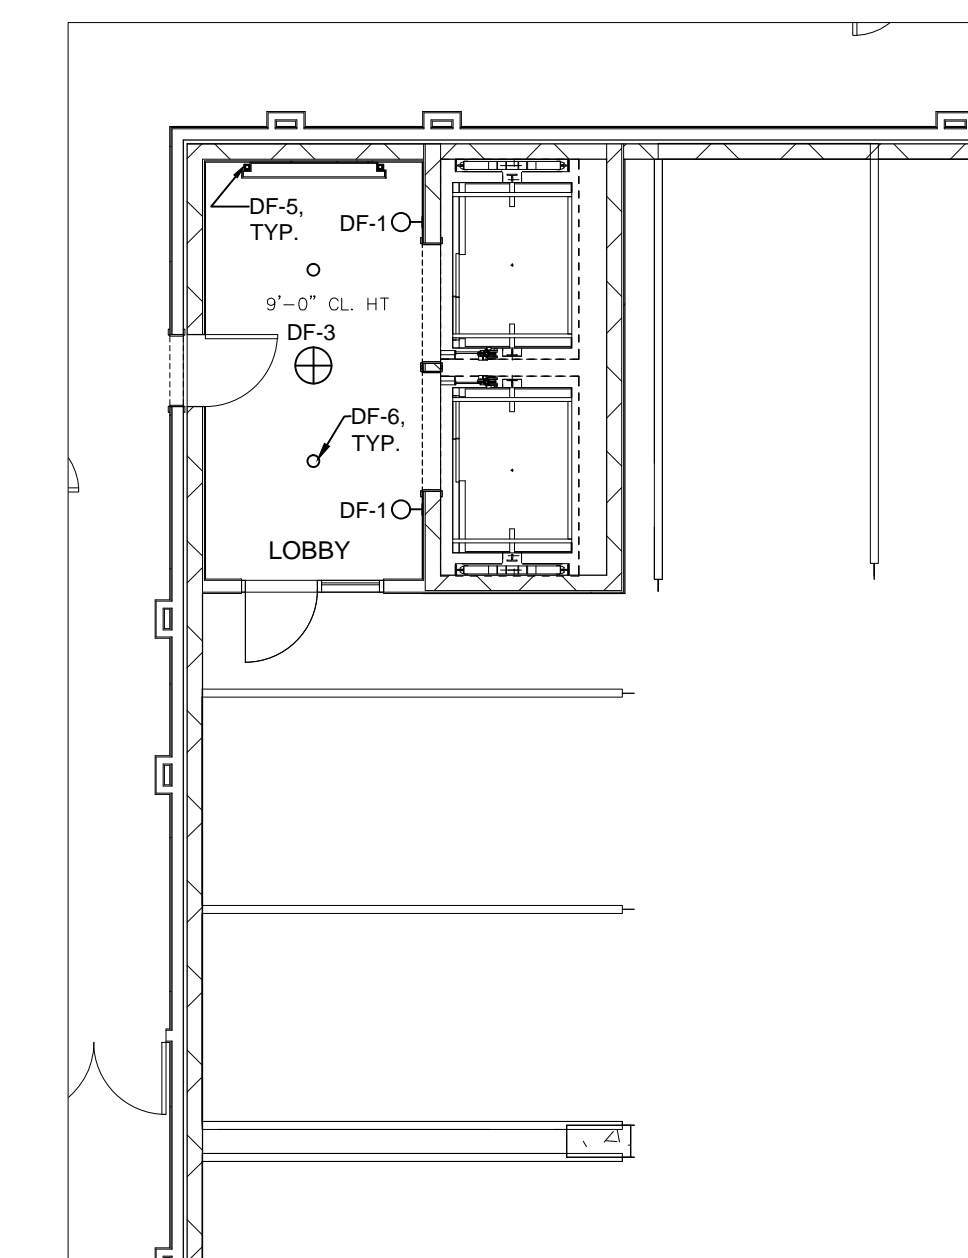

NW ELEV.
SCALE: 1/8" = 1'-0"

LEVEL 4