

PLEASANT VALLEY APARTMENTS

AUSTIN, TEXAS

BUILDING PERMIT SET

05-12-2015

PPDS

[design + interiors]

1012 mopac circle, suite 200
austin, texas 78746
512.328.1883 [p]
512.328.7448 [f]
www.pfds-inc.com
www.pfds-inc.com/blog

drawn by:
L.Wiggins

checked by:
J. Paulson

Date:
05.12.2015

REVISIONS


FOR:
PERMIT

SCALE: AS NOTED

TABLE OF CONTENTS

ID0.0	INTERIOR DESIGN COVER SHEET
ID2.2	LEVEL 1 DECORATIVE LIGHTING PLAN
ID2.3	LEVEL 2 DECORATIVE LIGHTING PLAN
ID2.4	LEVEL 5 DECORATIVE LIGHTING PLAN
ID2.5	DECORATIVE LIGHTING SCHEDULE

PLEASANT VALLEY APARTMENTS
AUSTIN, TEXAS

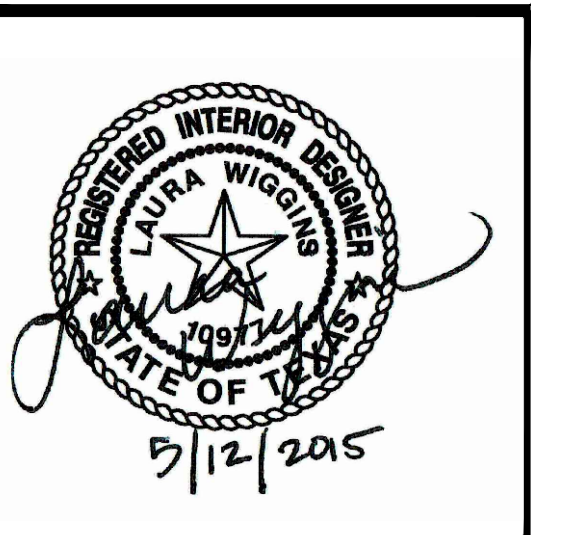

COVER SHEET

ID0.0

drawn by:
 L. Wiggins

checked by:
 J. Paulson

Date:
 05.12.2015

REVISIONS

FOR:
 PERMIT


SCALE: AS NOTED

PLEASANT VALLEY APARTMENTS
 AUSTIN, TEXAS




DECORATIVE
 LIGHTING PLAN
 LEVEL 1


ID2.2

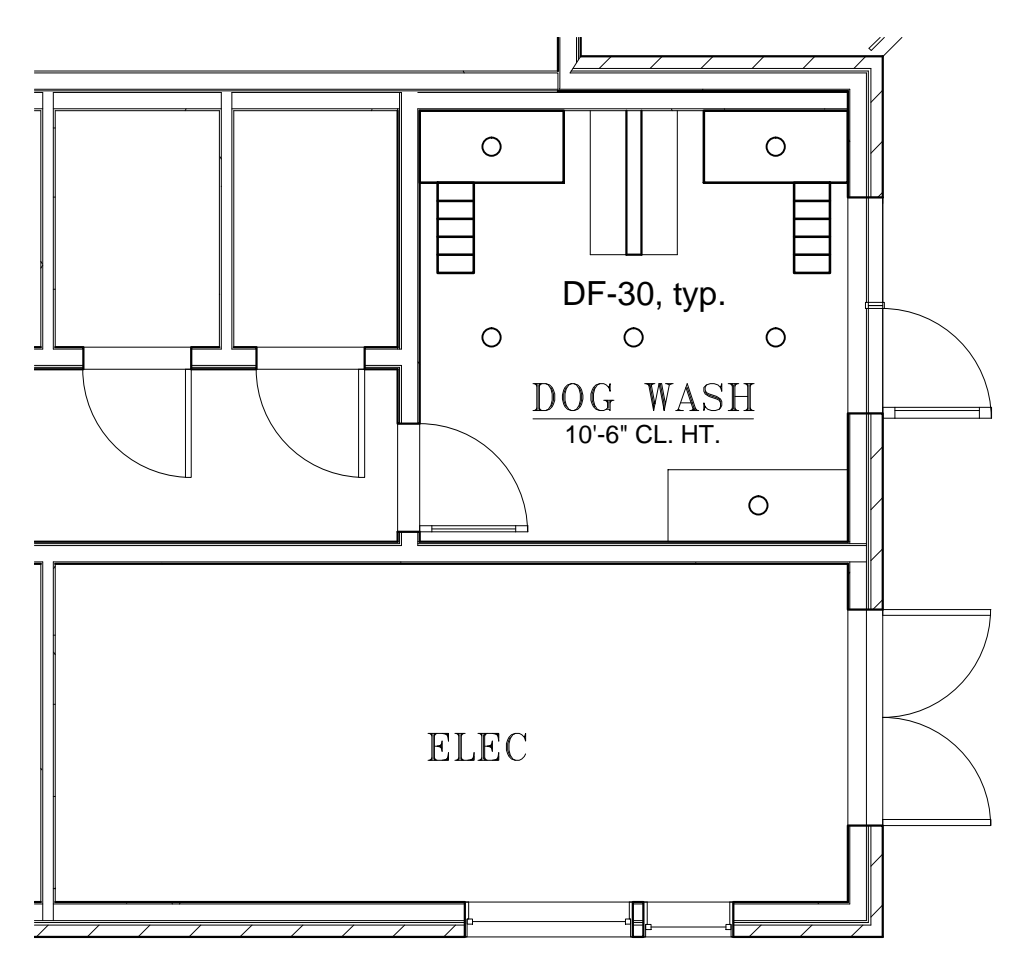


D DOG WASH
 SCALE: 3/16" = 1'-0"

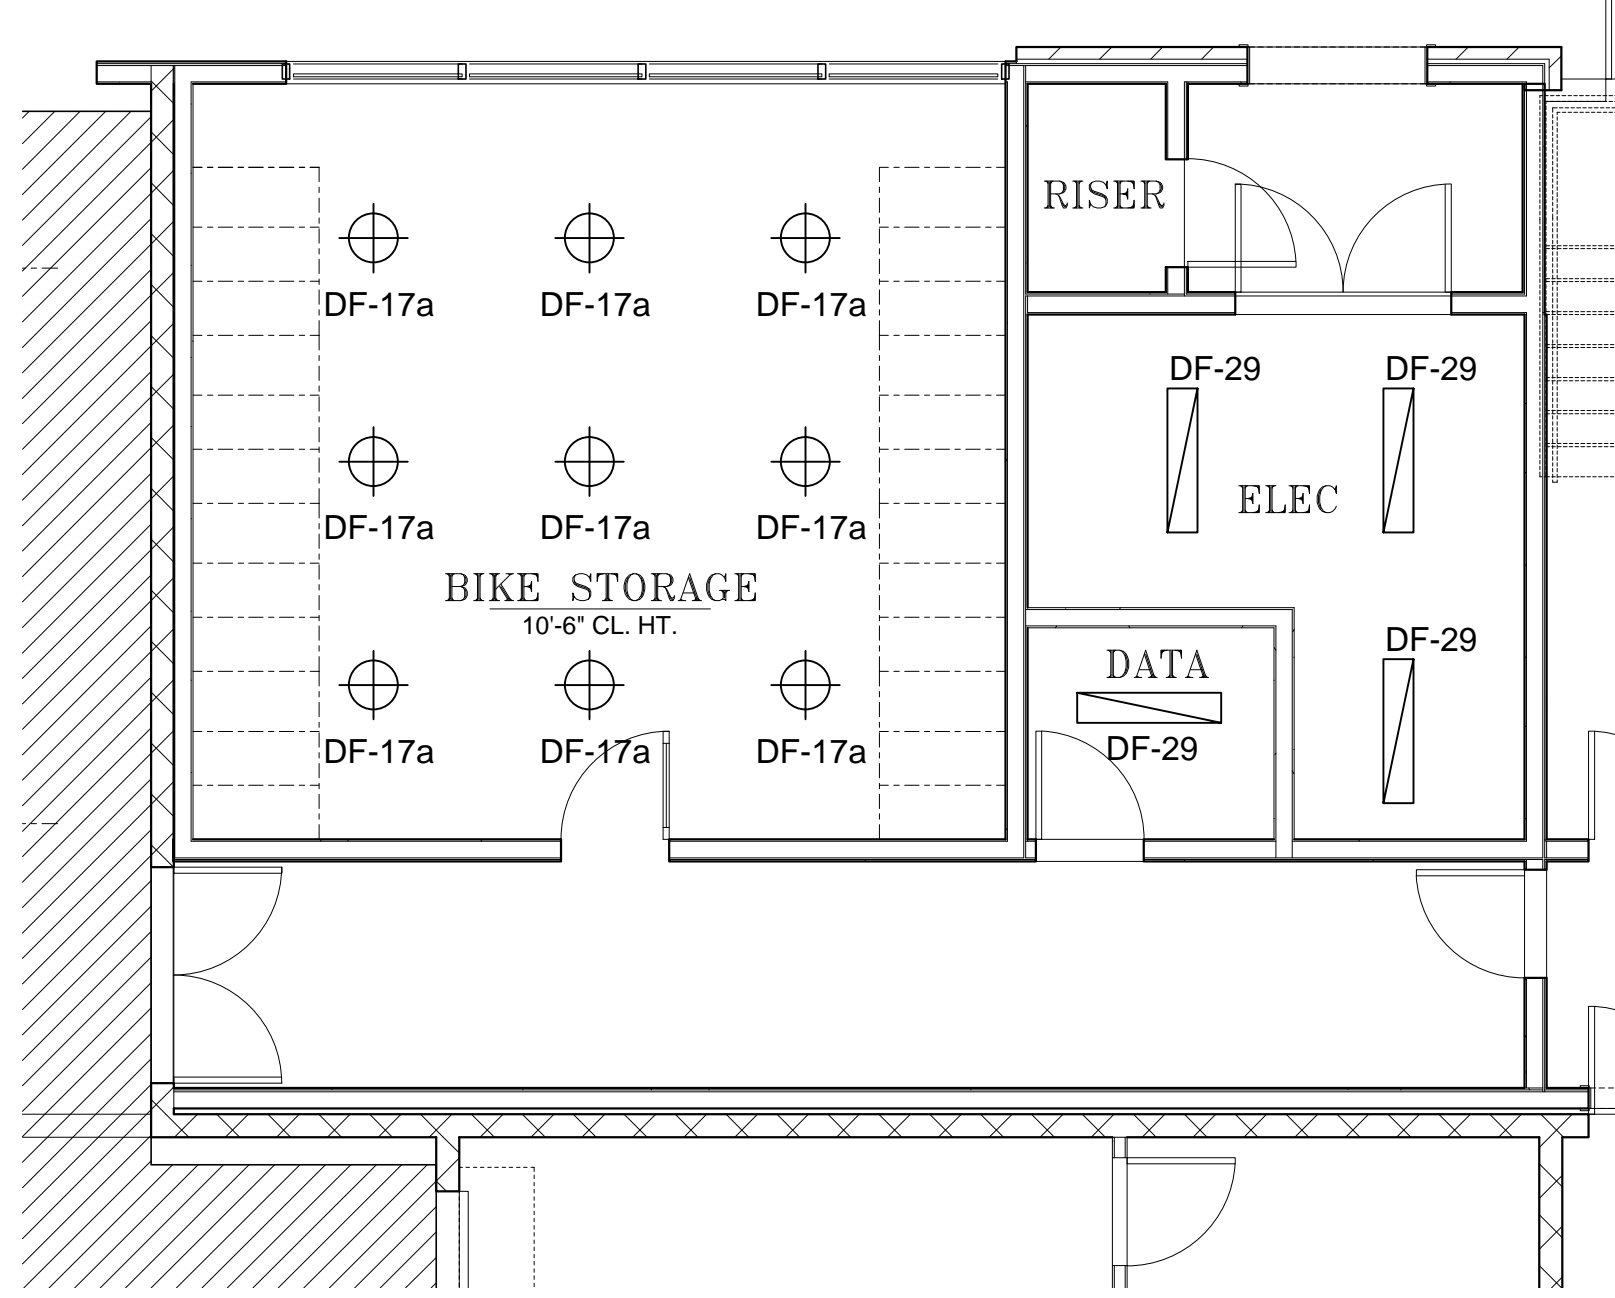


C BIKE STORAGE
 SCALE: 3/16" = 1'-0"

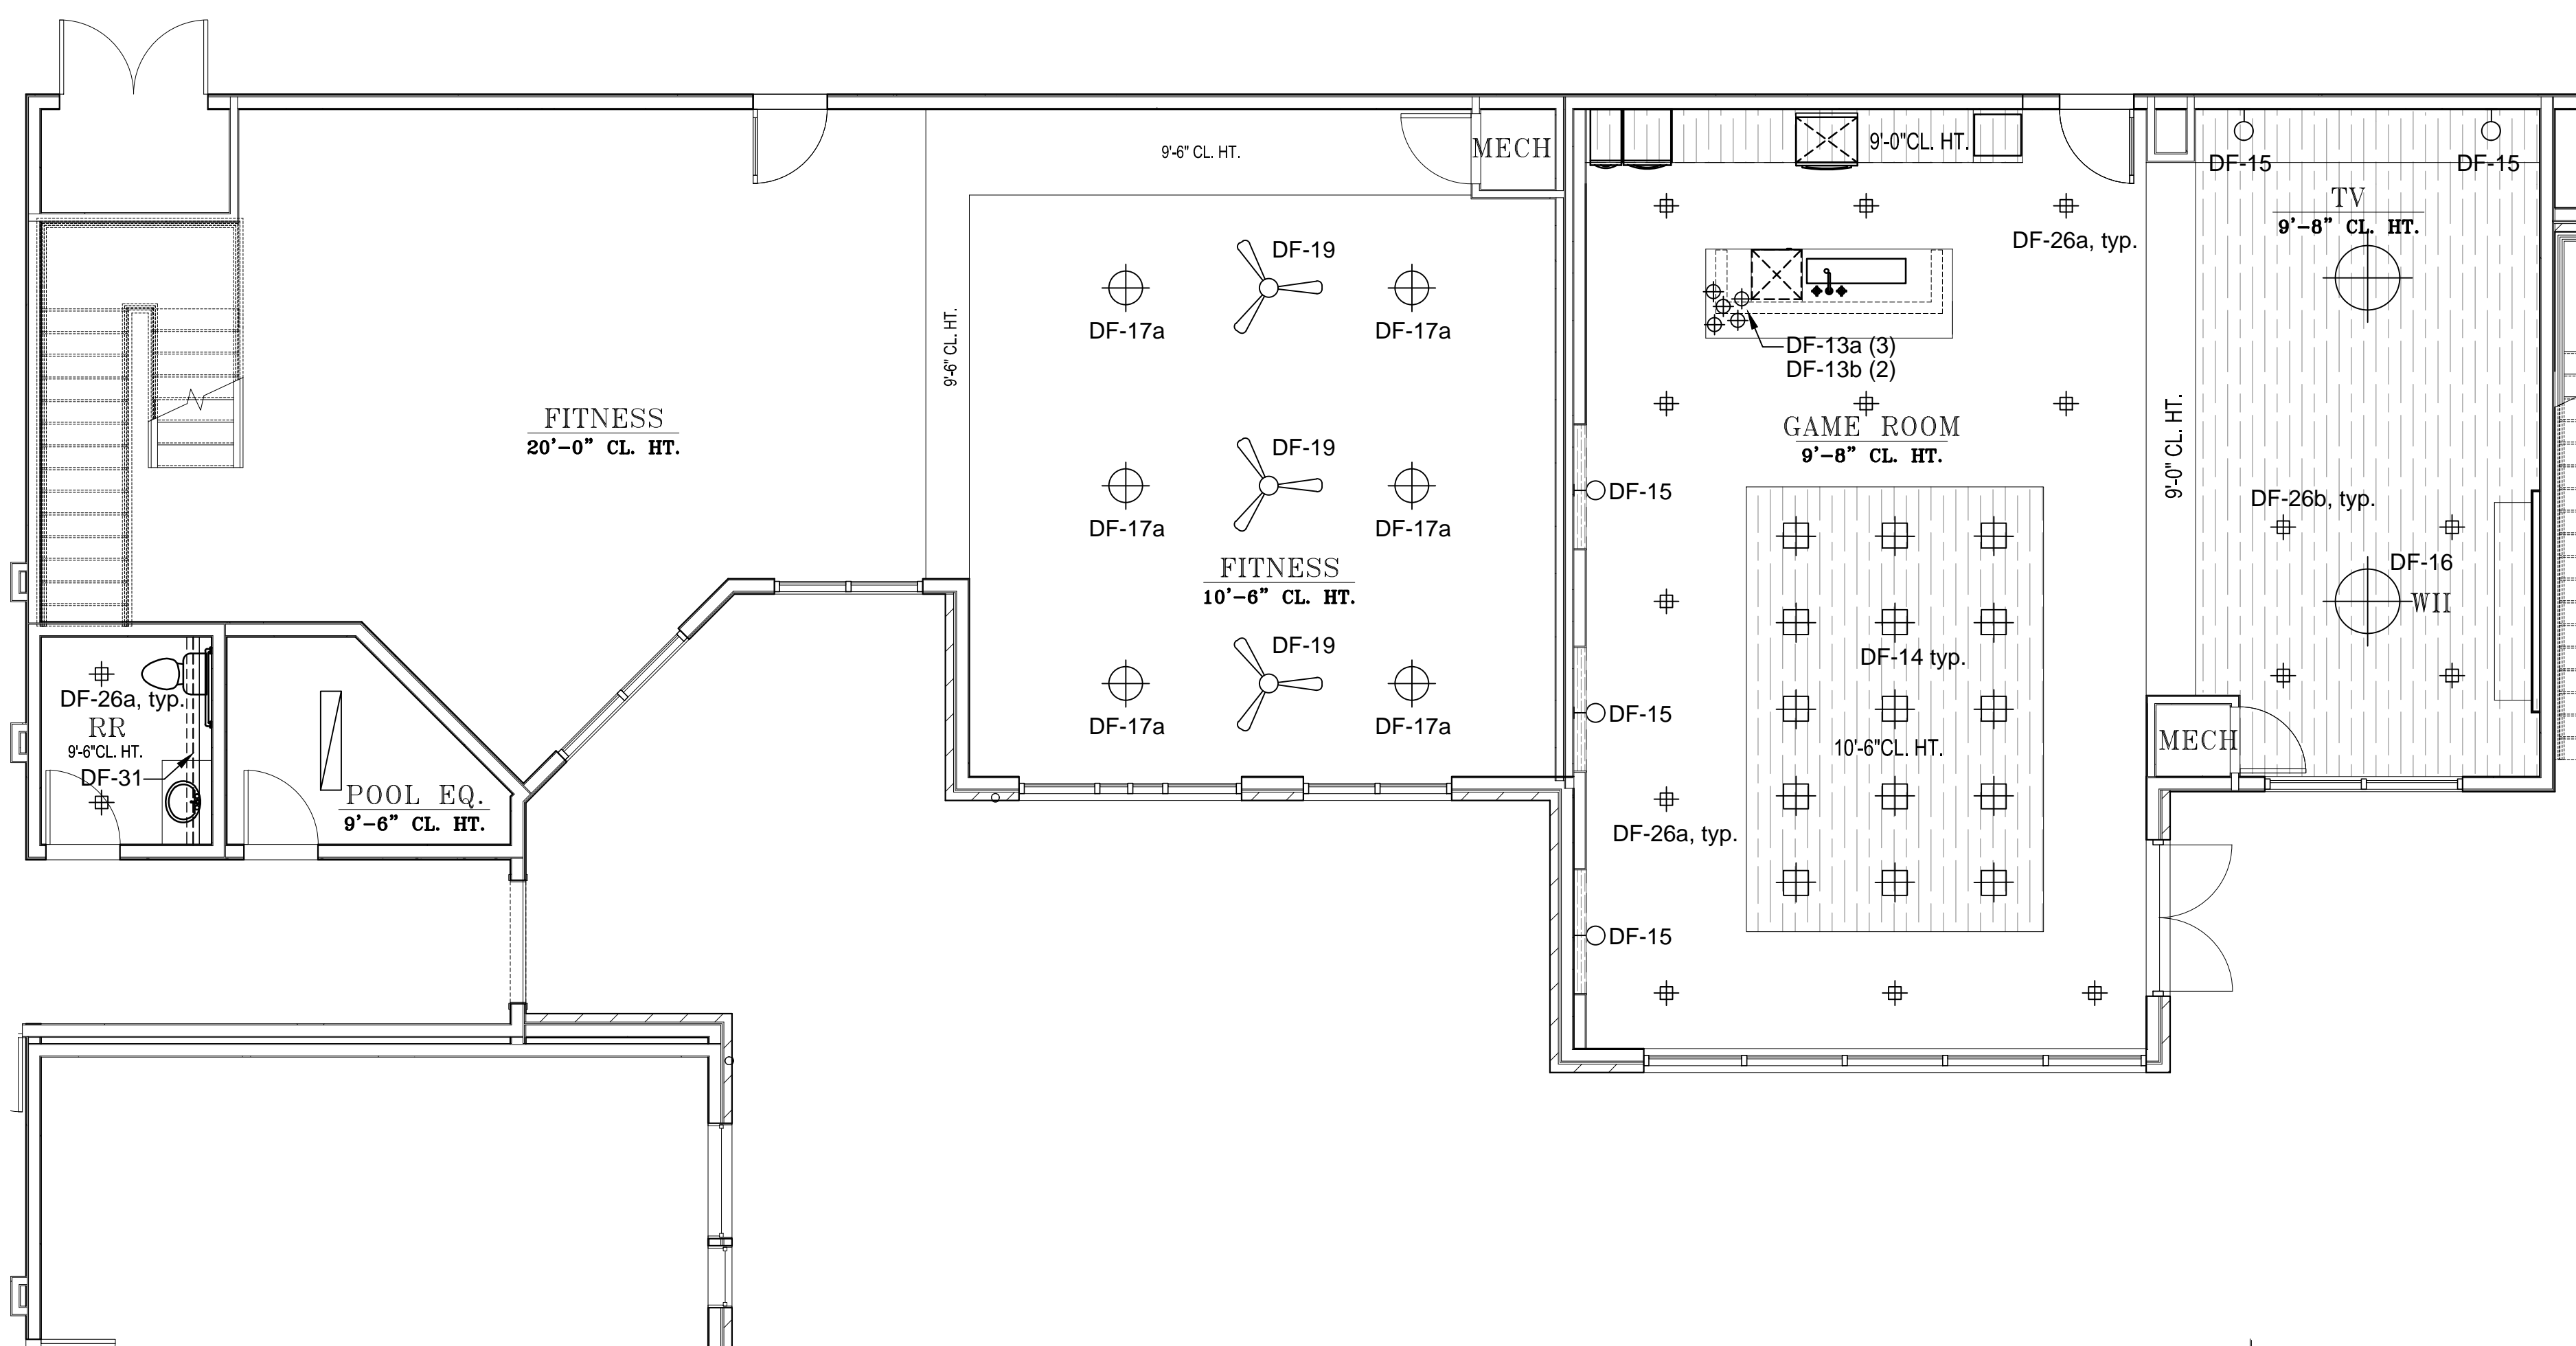

B GAME ROOM, FITNESS
 SCALE: 3/16" = 1'-0"

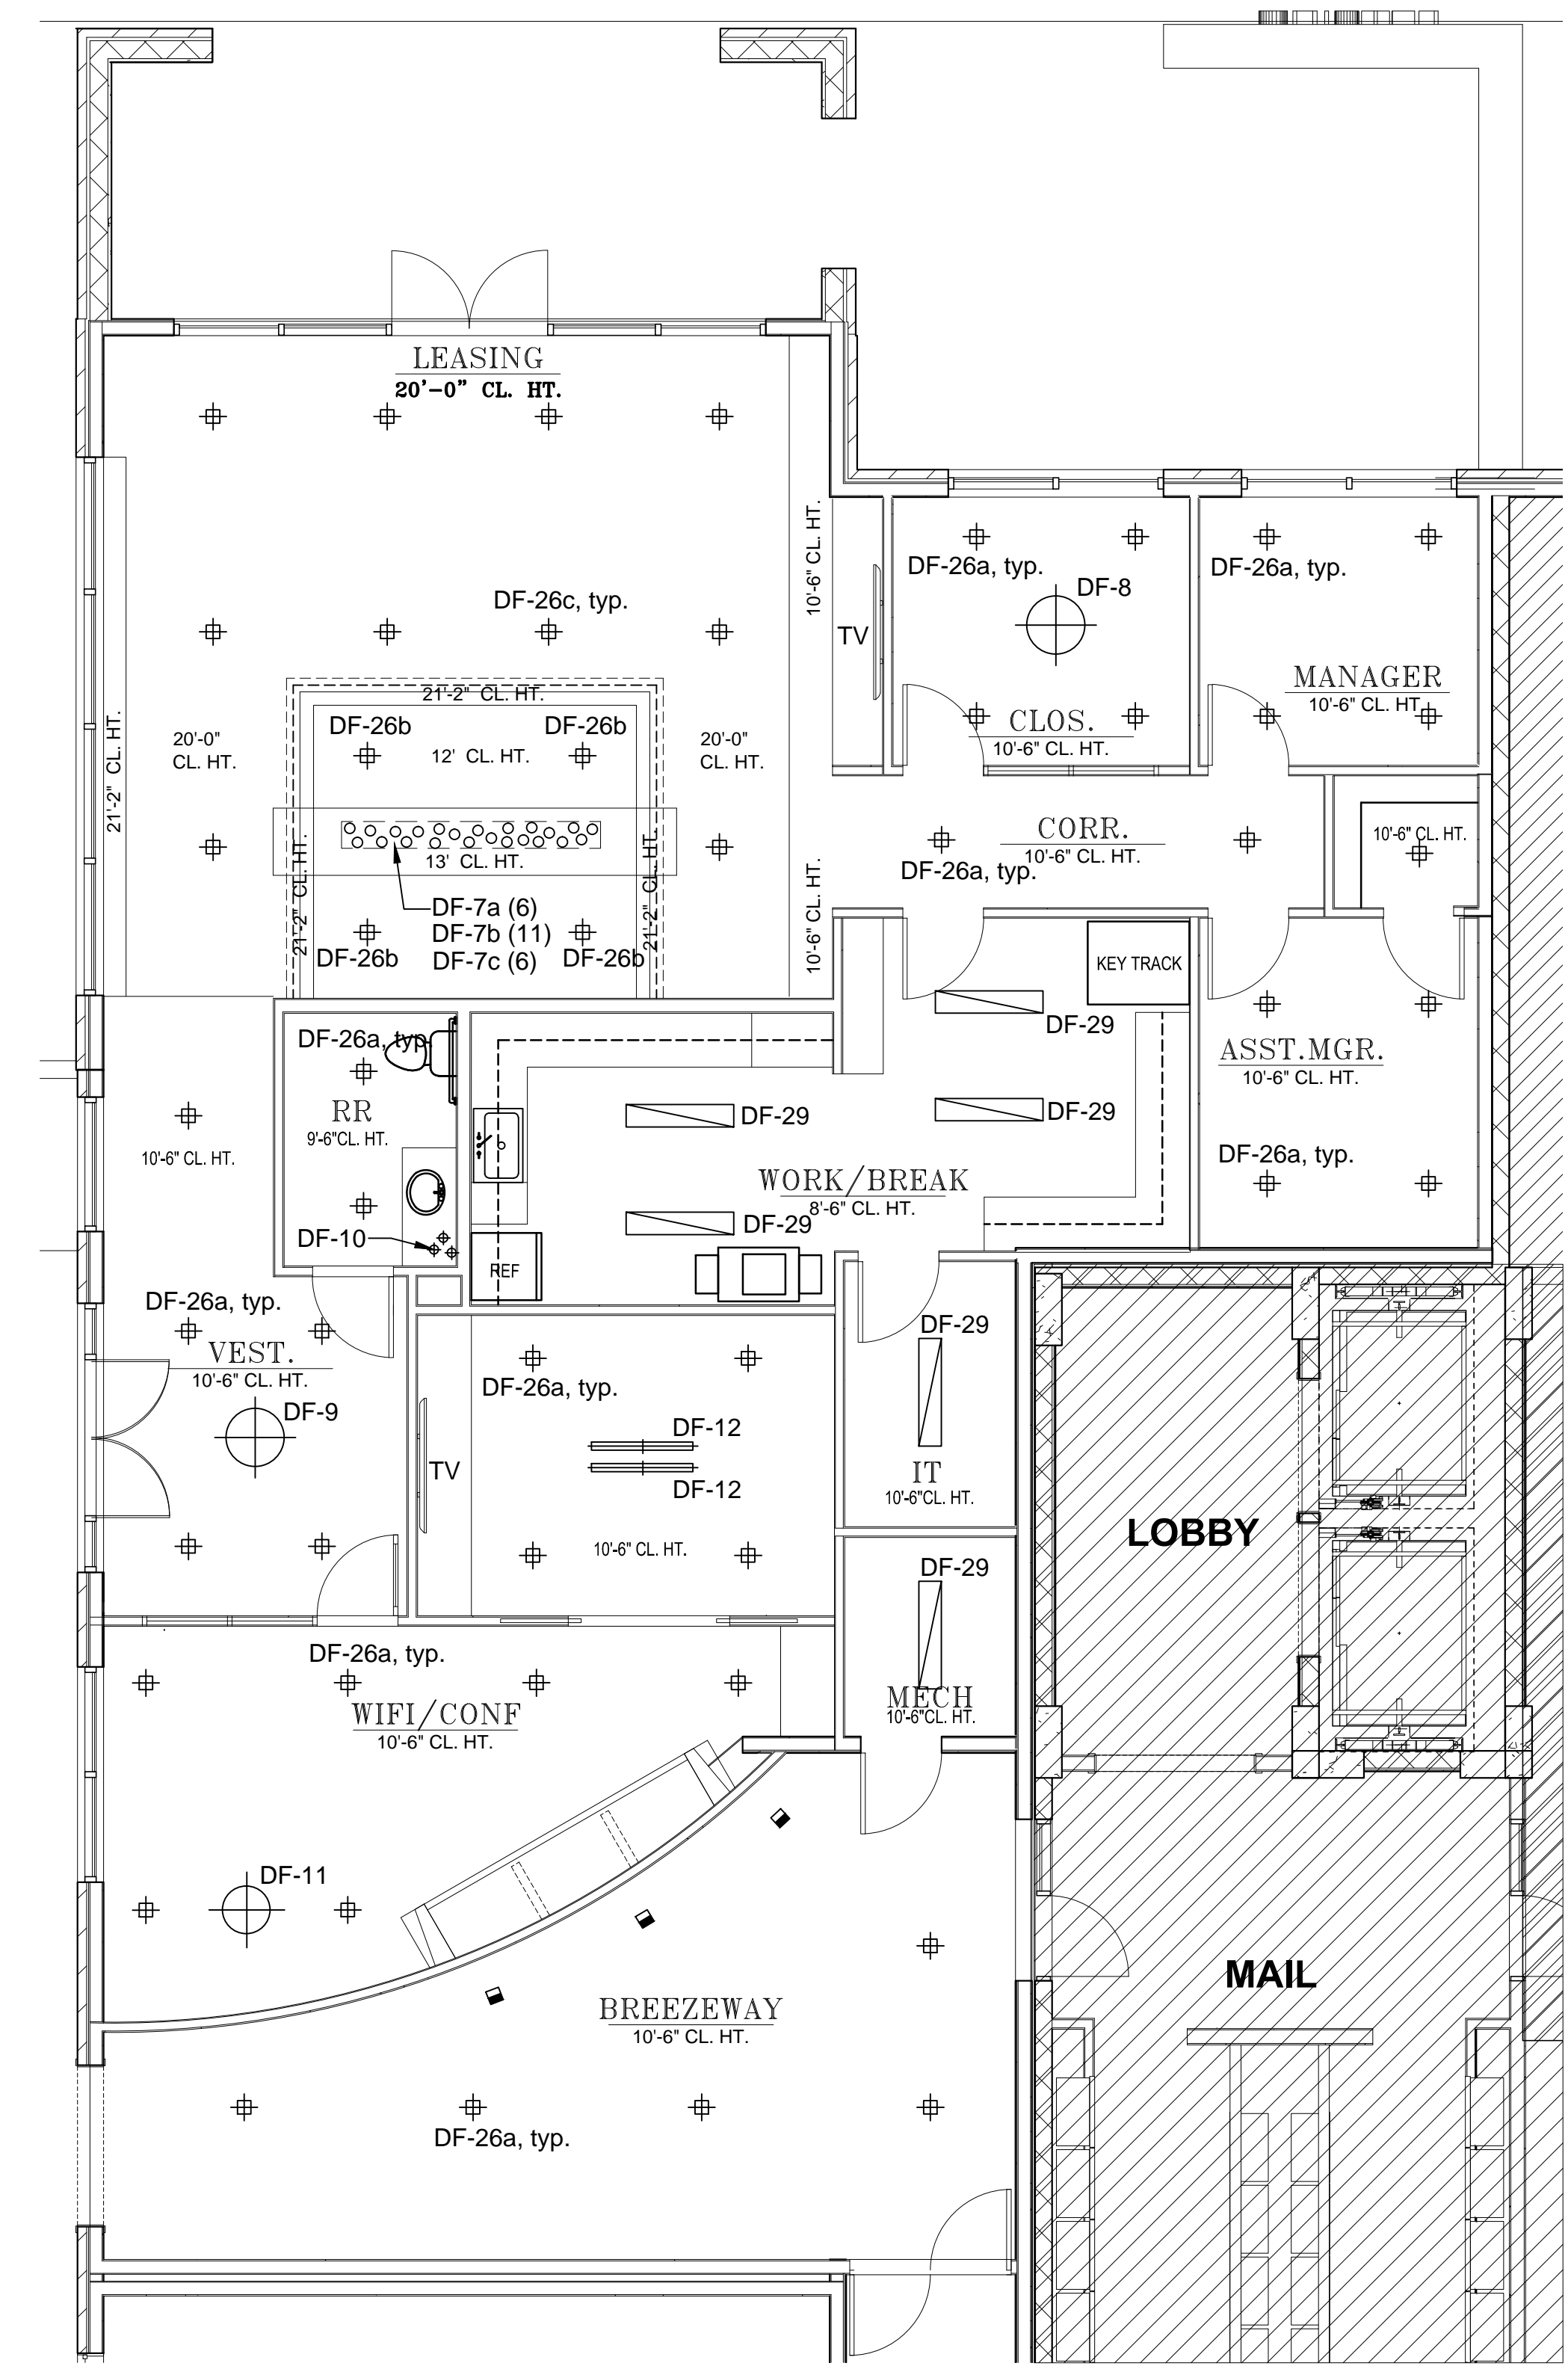

A LEASING, WIFI, CONFERENCE
 SCALE: 3/16" = 1'-0"

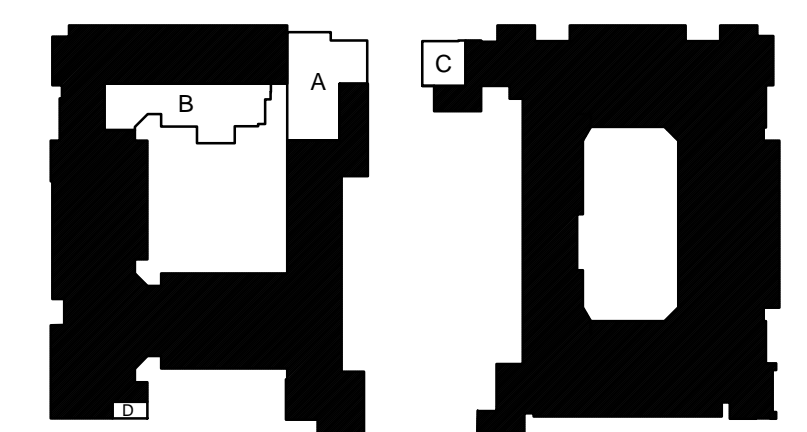


drawn by:
L.Wiggins

checked by:
J. Paulson

Date:
05.12.2015



REVISIONS

FOR:
PERMIT
SCALE: AS NOTED

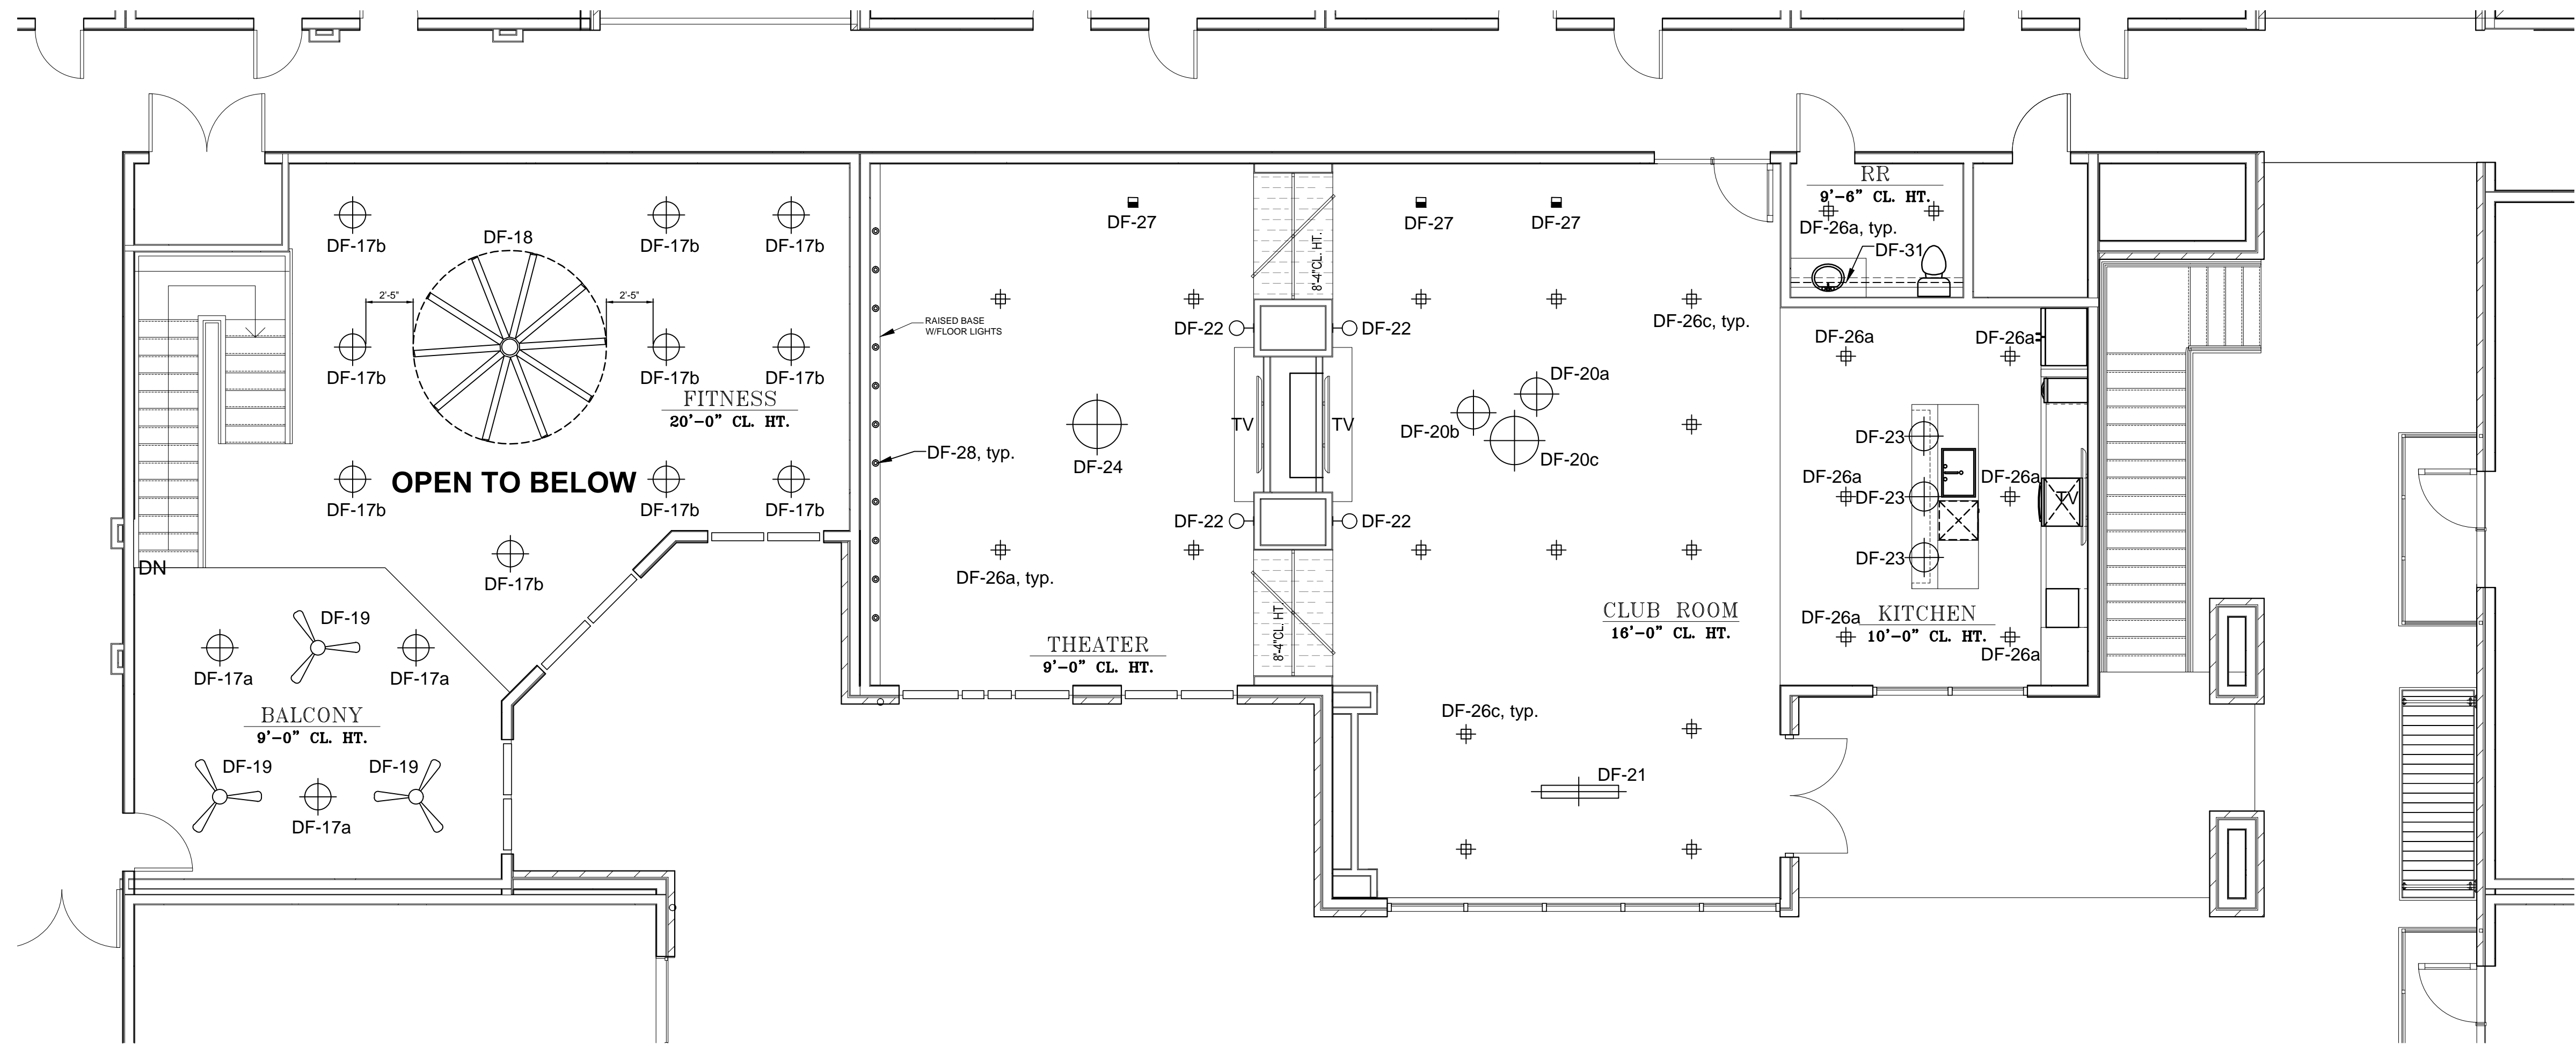

E CLUB / THEATER- LEVEL 2
 SCALE: 3/16" = 1'-0"

PLEASANT VALLEY APARTMENTS
 AUSTIN, TEXAS

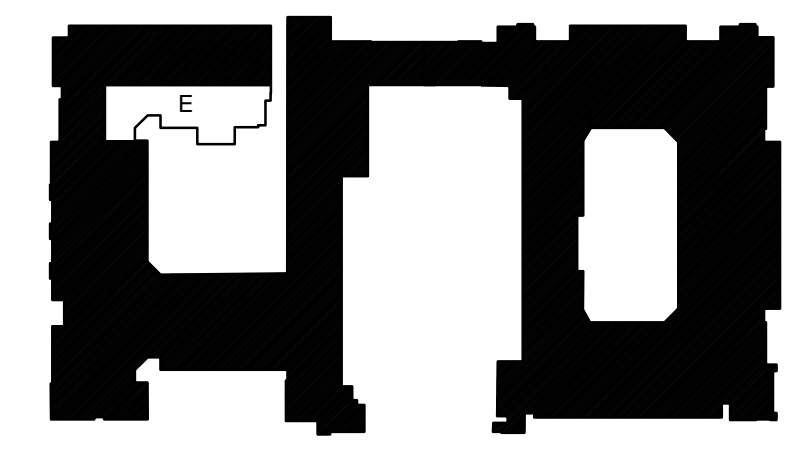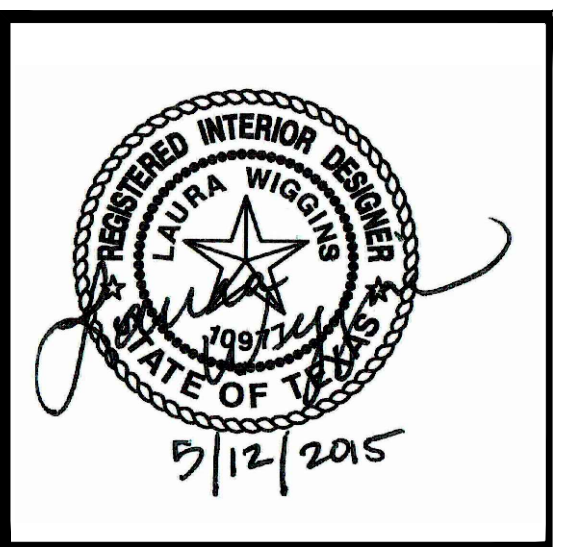

DECORATIVE
LIGHTING PLAN
LEVEL 2

ID2.3

drawn by:
 L.Wiggins


 checked by:
 J. Paulson

 Date:
 05.12.2015

 REVISIONS

FOR:
 PERMIT

 SCALE: AS NOTED

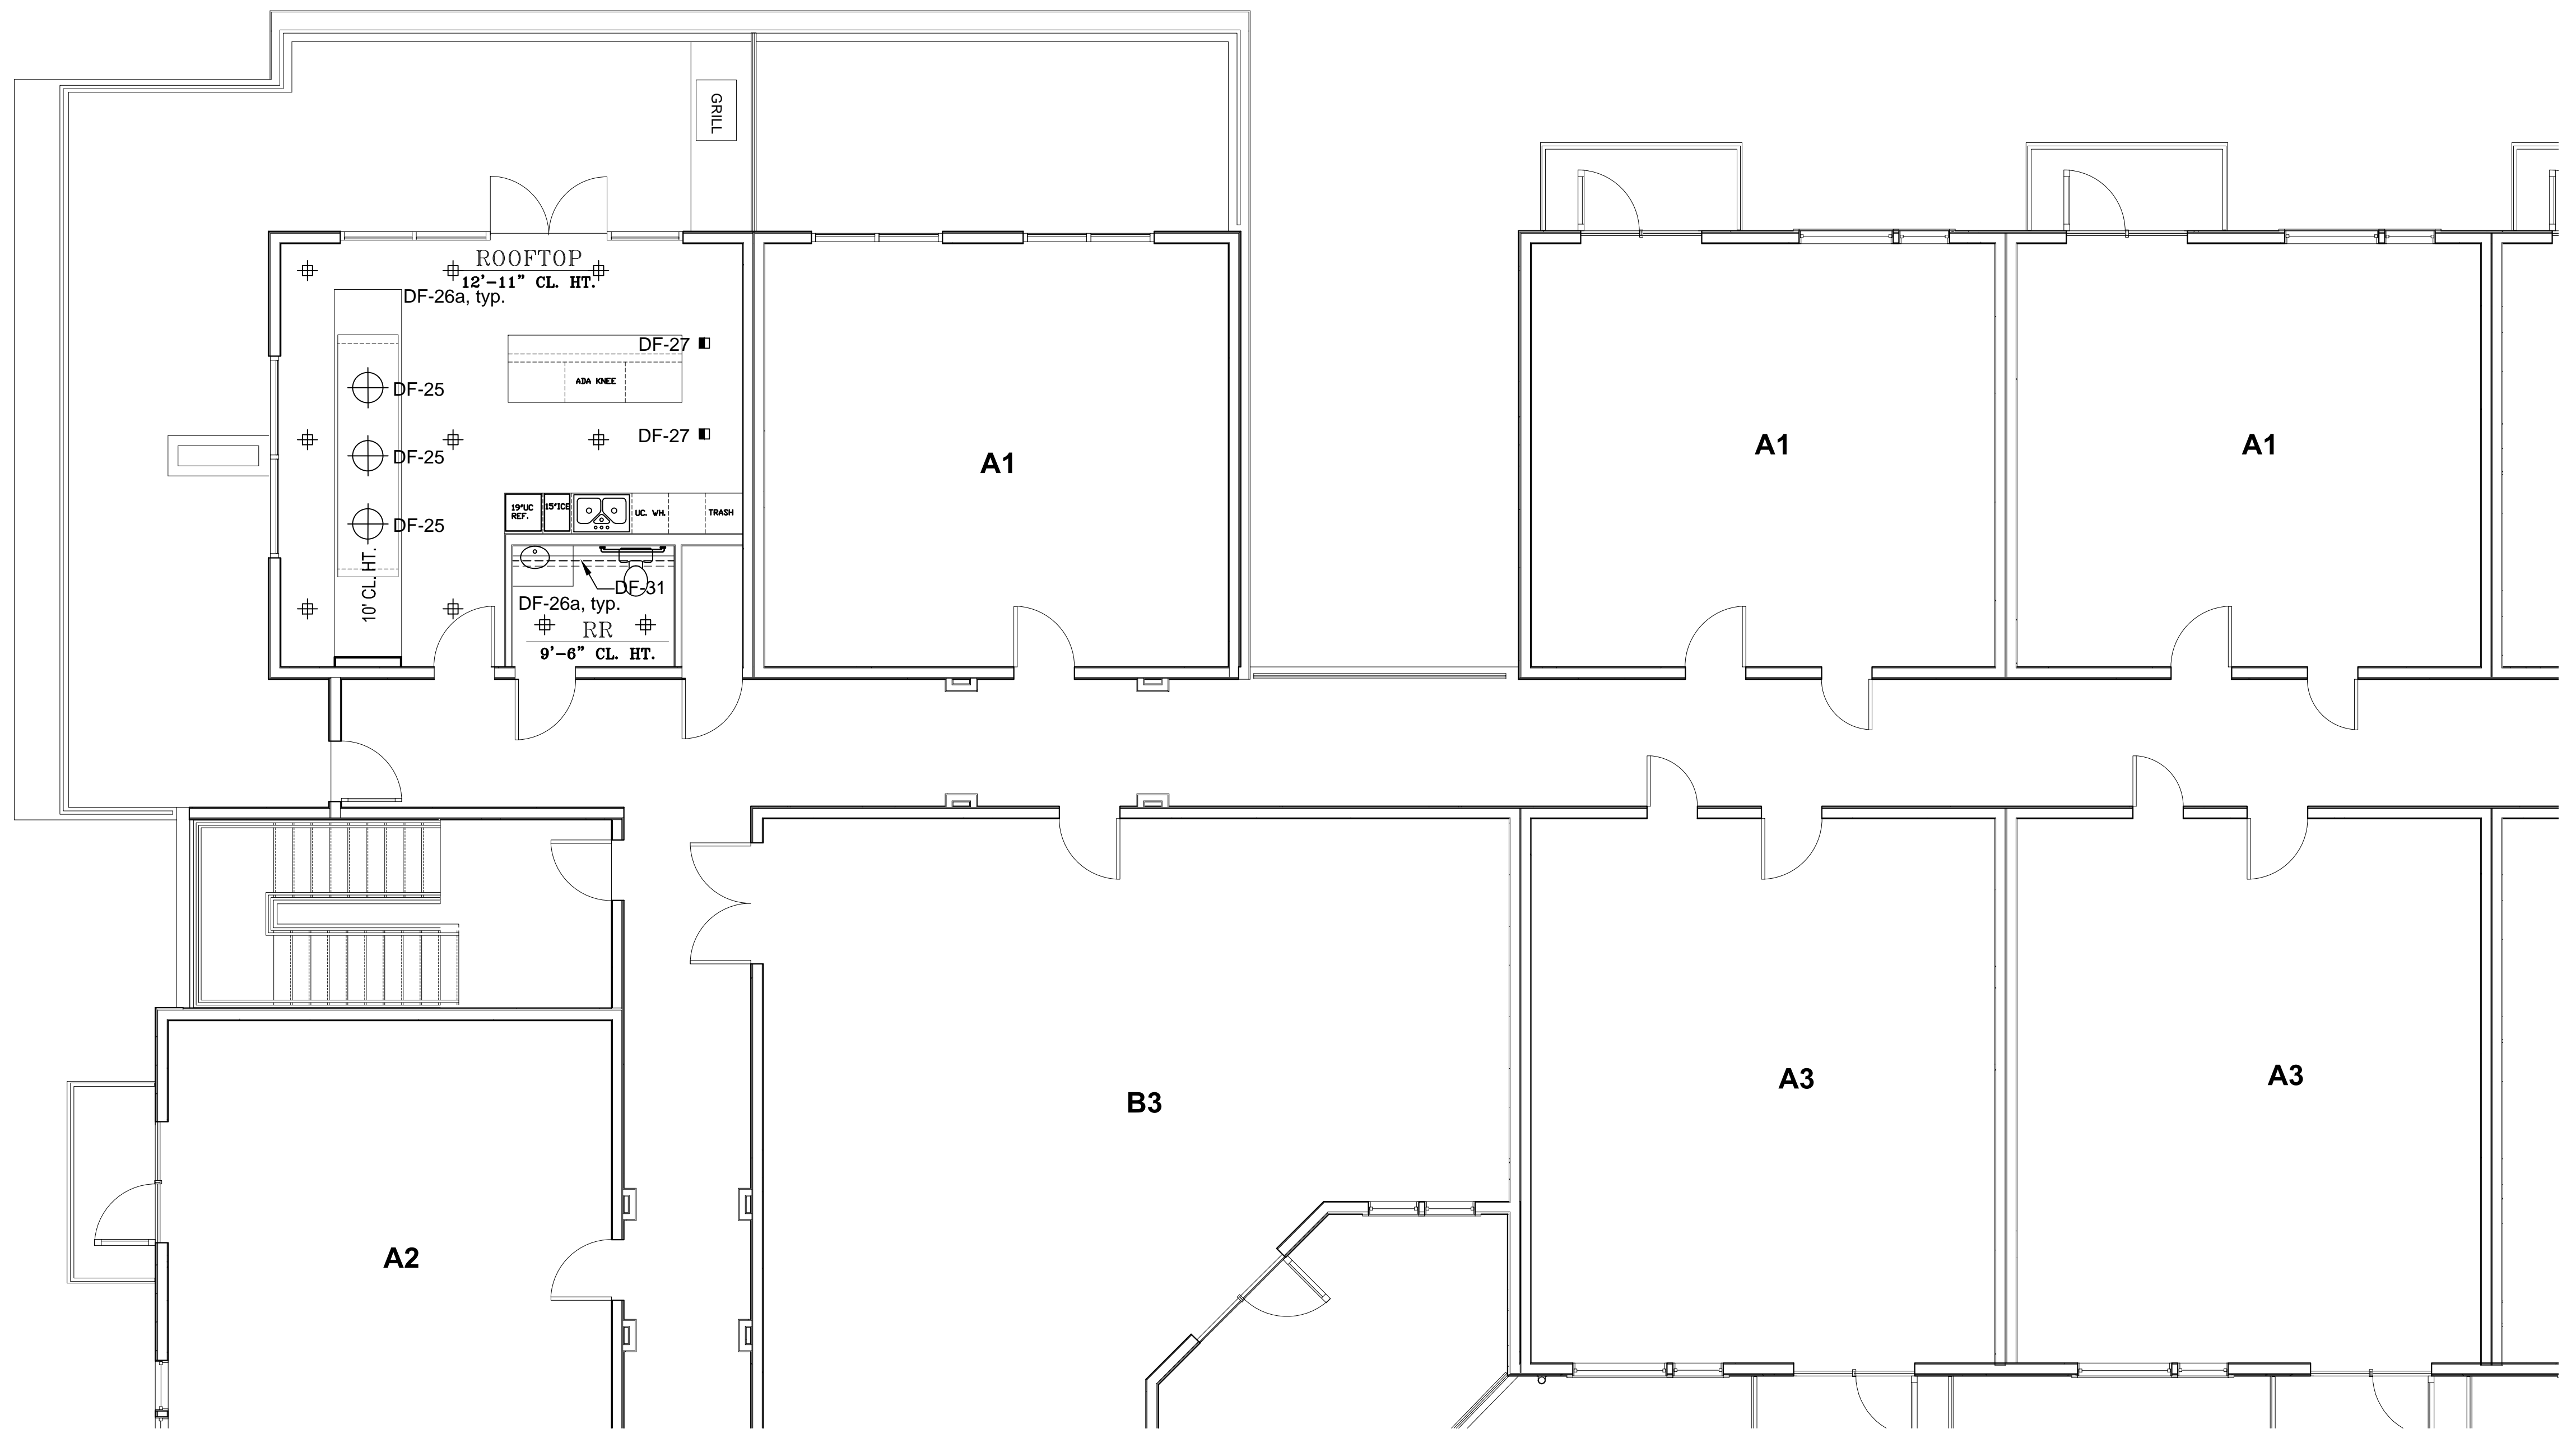


F ROOF TOP- LEVEL 5

 SCALE: 3/16" = 1'-0"

PLEASANT VALLEY APARTMENTS

 AUSTIN, TEXAS

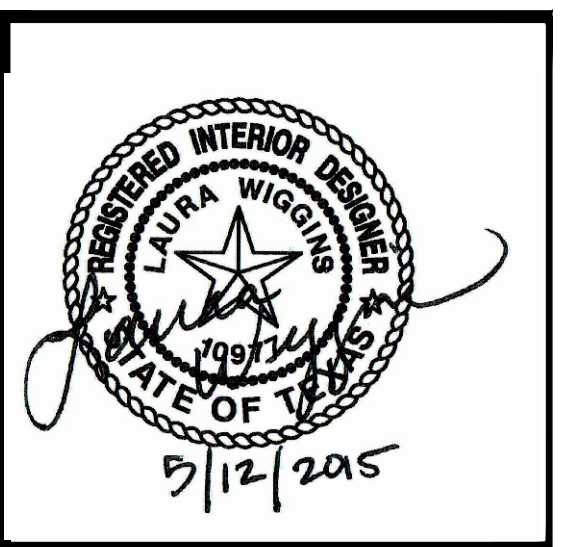

DECORATIVE

 LIGHTING PLAN

 LEVEL 5

ID2.4

PLEASANT VALLEY APARTMENTS LIGHTING SCHEDULE					
LEASING, CLUBHOUSE, BIKE STORAGE, AND DOG WASH					
Symbol	Description	Manufacturer	Product	Lamp	Finish
DF-7a	Pendant Light	3M	Vessel Small 2" VSL-PD-SM-27-BK-BK; 2.2"W x 2.4"H	LED 2700K	Black w/ Black Canopy
DF-7b	Pendant Light	3M	Vessel Medium 6" VSL-PD-MD-27-BK-BK; 2.2"W x 6.6"H	LED 2700K	Black w/ Black Canopy
DF-7c	Pendant Light	3M	Vessel Large 12" VSL-PD-LG-27-BK-BK; 2.2"W x 11.9"H	LED 2700K	Black w/ Black Canopy
DF-8	Chandelier	Arteriors	Caviar Fixed Large Cluster #DK89901; 28.5"Diam x 47"H	(8) 40W B10 Incandescent	Smoke / Brown Nickel
DF-9	Chandelier	Mooi	Heraclueum II Small; 28.3" Diam x 20.9"H	(45) LED 2700K	Copper
DF-10	Pendant Light	LBL	VIGI Low Voltage Pendant HS774; mono-point; 1.8"W x 21.2"H	LED 3000K, 5W	Rose Gold
DF-11	Pendant Light	Tech Lighting	Karma Large Pendant; 700KRMLBB-LED827; 21.3"W x 18.6"H	LED 2700, A21 19W lamp	Black
DF-12	Pendant Light	Tech Lighting	Knox Linear Suspension; 700LSKNOXB-LED; 3.6"W x 2.17"H; DIMMABLE	LED 3000K	Black
DF-13a	Pendant Light	Grupo B.Lux	Aspen S17_A LED; 6.75"W x 13.25"H	LED 3000K	TBD
DF-13b	Pendant Light	Grupo B.Lux	Aspen S17_B LED; 6.75"W x 17"H	LED 3000K	TBD
DF-14	Surface Mount	3G Lighting	Kubo 12" Single, 3G-SKU1201-32CFL-120-E-SV; 12"W x 13.25"H	32W CFL	White Acrylic / Silver Collar
DF-15	Wall Sconce	Noir	Enzo Sconce LAMP420; 12.5"W x 30.5"E x 34"H; DIMMABLE	(1) 60W Incandescent	Black Metal
DF-16	Surface Mount	Zaneen	Mirya Surface D2-2067; 31.5"Diam x 5 7/8"H; DIMMABLE	E26 CFL (30W/lamp - 120W total)	Ivory Shade / Opal Satined Diffus
DF-17a	Surface Mount	Eureka Lighting	Turbo Surface 4766-SCR; 16.39"Diam x 9.83"H	LED 3000K, 26W	Black / Black
DF-17b	Pendant Light	Eureka Lighting	Turbo Stem 4266B-SCR; 16.39"Diam x 9.83"H,	LED 3000K, 26W	Black / Black
DF-18	Large Ceiling Fan	Big Ass Fan	Essence 10' Fan used with a 3' Extension Tube to achieve total height of 44"MA	None	TBD
DF-19	Ceiling Fan	Fanimation	Zonix FP4620BL; 54" Blade sweep, no light kit, 6" Down rod	None	Black / Black
DF-20a	Pendant Light	Foscarini	Allegretto Ritmico Suspension; 20.2"D x 22.7"H	(2) 75W E26 PAR30 Halogen	Black
DF-20b	Pendant Light	Foscarini	Allegretto Vivace Suspension; 19.8"D x 27.4"H	(2) 75W E26 PAR30 Halogen	Brown
DF-20c	Pendant Light	Foscarini	Allegretto Assai Suspension; 29.8"D x 31.1"H	(2) 75W E26 PAR30 Halogen	Gold
DF-21	Pendant Light	Cerno Group	Vix 48 Pendant; 07-130-W; 48"L x 8"W x .25"H; DIMMABLE	LED 2700K; 16W	Oiled Walnut
DF-22	Wall Sconce	Lumetta Inc.	Shadow Box Sconce; W2093-F3-D921-D61-2/14WT5-120; 11.5"Wx24"Hx4"D	(2) T5 Fluor/14W	Black/Trans Cool/MT White
DF-23	Pendant Light	Feiss	Beso Collection; F2706/1DBZ-F; 18"W x 16 1/8"H	GU24 CFL 13W	Dark Bronze
DF-24	Surface Mount	AXO Light	Velvet Surface; UPVEL100LED; 39 3/8" x 12.25"H DIMMABLE	LED 2700K GU24 LED 51W	TBD
DF-25	Pendant Light	Tom Dixon	Copper Shade 45cm; 17.7D x 16.4"H	(1) 60W E26 (med.) G30 White Glob	Copper / Black Canopy
DF-26a	Recessed Downlight	Gotham	6" Evo Square; EVO-SQ-30-10-6WR; 1000 Lumens; 6" Square	LED 3000K; 22W	White
DF-26b	Recessed Downlight	Gotham	6" Evo Square; EVO-SQ-30-10-6BR; 1000 Lumens; 6" Square; DIMMABLE	LED 3000K; 22W	Black
DF-26c	Recessed Downlight	Gotham	6" Evo Square; EVO-SQ-30-22-6WR; 2200 Lumens; 6" Square	LED 3000K; 32W	White
DF-27	Recessed Wall Washer	Gotham	6" Evo Square; EVO-SQLW-30-10-6WR; 1000 Lumens; 6" Square; DIMMABLE	LED 3000K; 22W	White
DF-28	Floor Uplight	Bega-US	Small Scale in-grade Luminaire- 7019LED3K; 4-5/8" x 3-7/8"H; 4.3W LED	LED 3000K	Stainless Steel
DF-29	Surface Mount	Lithonia	Surface Volumetric; ST8-2-32; 48"L x 10 1/8"W x 3 7/8"H	(2) 32W T8 Fluor	White
DF-30	Recessed Downlight (Wet)	TBD	6" Recessed can light for wet locations	32W CFL	White
DF-31	Cove Lighting	Tivoli Lighting	Platinum Cove LED; Series 01; PTCL-01-U-32-12	LED 3200K	Black

1 DECORATIVE LIGHTING SCHEDULE

drawn by:
L.Wiggins

checked by:
J. Paulson

Date:
05.12.2015

REVISIONS

FOR:
PERMIT

SCALE: AS NOTED

PLEASANT VALLEY APARTMENTS
AUSTIN, TEXAS



DECORATIVE
LIGHTING
SCHEDULE

ID2.5