


CLUBHOUSE LIGHT FIXTURE SCHEDULE					
MARK	SYMBOL	DESCRIPTION	MANUFACTURER	MODEL	LAMP
A	□	RECESSED FLUORESCENT DOWN LIGHT 1" APERTURE COMFORT CLEAR DIFFUSE FINISH SELF FLANGE PAINTED WHITE	LIGHTOLIER OR EQUAL	8022CCDW-1192BU	4 PIN CF 24W
B	⊕	OUTDOOR RECESSED CAN	JUNO LIGHTING	IC22LED-63-2TK-1/24W-1H-KIT	14 WATT
C	⊙	OUTDOOR SCENCE	HINKLEY	CASCADE 18348Z-LED	15 WATT
D	⚡	SURFACE TRAC LIGHT	TEGAN LIGHTING	RETRAC RT5C6	10W 3000K LED
E	⊕	MEZZO GRANDE PENDANT	LBL LIGHTING	# LPTTB	(1) CFL 6X24G-2 TRIPLE TUBE 32 WATT
F	⊕	"ZANE LINEAR SUSPENSION" Z ANTIQUE BRONZE	TECH LIGHTING	100LS2H44Z-LED	LED - 40W
G	⊙	OPAL ACRYLIC WALL SCENCE	LBL LIGHTING	PH 614 0Y SCCFHE	LINEAR FLOURESCENT T5HO MINI BI-PIN 34 WATT
H	⊕	"PARI PENDANT" NATURAL FINISH FLARED CLEAR OUTER SHADE	PHILLIPS FORCAST LIGHTING	FC0024-04T	3-60 WATT E26 MED. BASE
J	▬	DIRECT / INDIRECT SUSPENDED	SELECTED BY OWNER	SELECTED BY OWNER	4-32W T8
K	⊗	CEILING MOUNTED FLIORESCENT WRAP AROUND	WAREHOUSE LIGHTING	207A-32W	2-32W T8


L	▬	DIRECT / INDIRECT SUSPENDED	FINELITE	HIGH PERFORMANCE 4" APERTURE (HP-4) DIRECT / INDIRECT HP-4 ID-8"-50-50-3500-T6	(2) T5 LED
M	⊕	RUFUS LARGE CHANDELLER	NOIR	LAMP425L	(6) 60 WATT TYPE B BULBS
N	▬	RECTANGULAR WALL MOUNT FIXTURE (MEDIUM)	AXO LIGHTING	UPFW040FLEBCXX	MINI BI-PIN T-5
P	⊙	CLOSET LIGHT - CEILING MOUNT	TBD	TBD	60 WATT
R	⊕	BRAELYN 5 LIGHT CHANDELLER	KICHLER	430580Z	5 - 60 WATT A19 MEDIUM BASE
S	⊗	BALL CEILING FAN	THE MODERN FAN CO.	VAL-6W-52-1H-NL	N/A
T	⊗	ZONIX CEILING FAN	FANIMATION	FP46400B	N/A
U	⊕	FLUSH MOUNT	CIRCA LIGHTING	# SC4000	(1) 60 WATT TYPE A INCANDESCENT
EL	▬	BUILDING EMERGENCY WHITE 100 MIN. BATTERY	LITHONIS LIGHTING	LE-S-W-I-R-EL-N	2-12W 6V HALOCS.
X	⊗	BUILDING EXIT, 6" RED LETTERS - 3/4" HIGHEST SWITCH AND CHARGER, HARD WIRED WITH BATTERY BACKUP	LITHONIA LIGHT ALARMS XP OR EQUAL.	C 2 32	N/A

CONTRACTOR SHALL VERIFY FIXTURE SELECTIONS WITH OWNER / ARCHITECT PRIOR TO PURCHASE OR INSTALLATION.
REFER TO INTERIOR DESIGNER CUT SHEETS FOR FULL DESCRIPTION
CFL = COMPACT FLUORESCENT

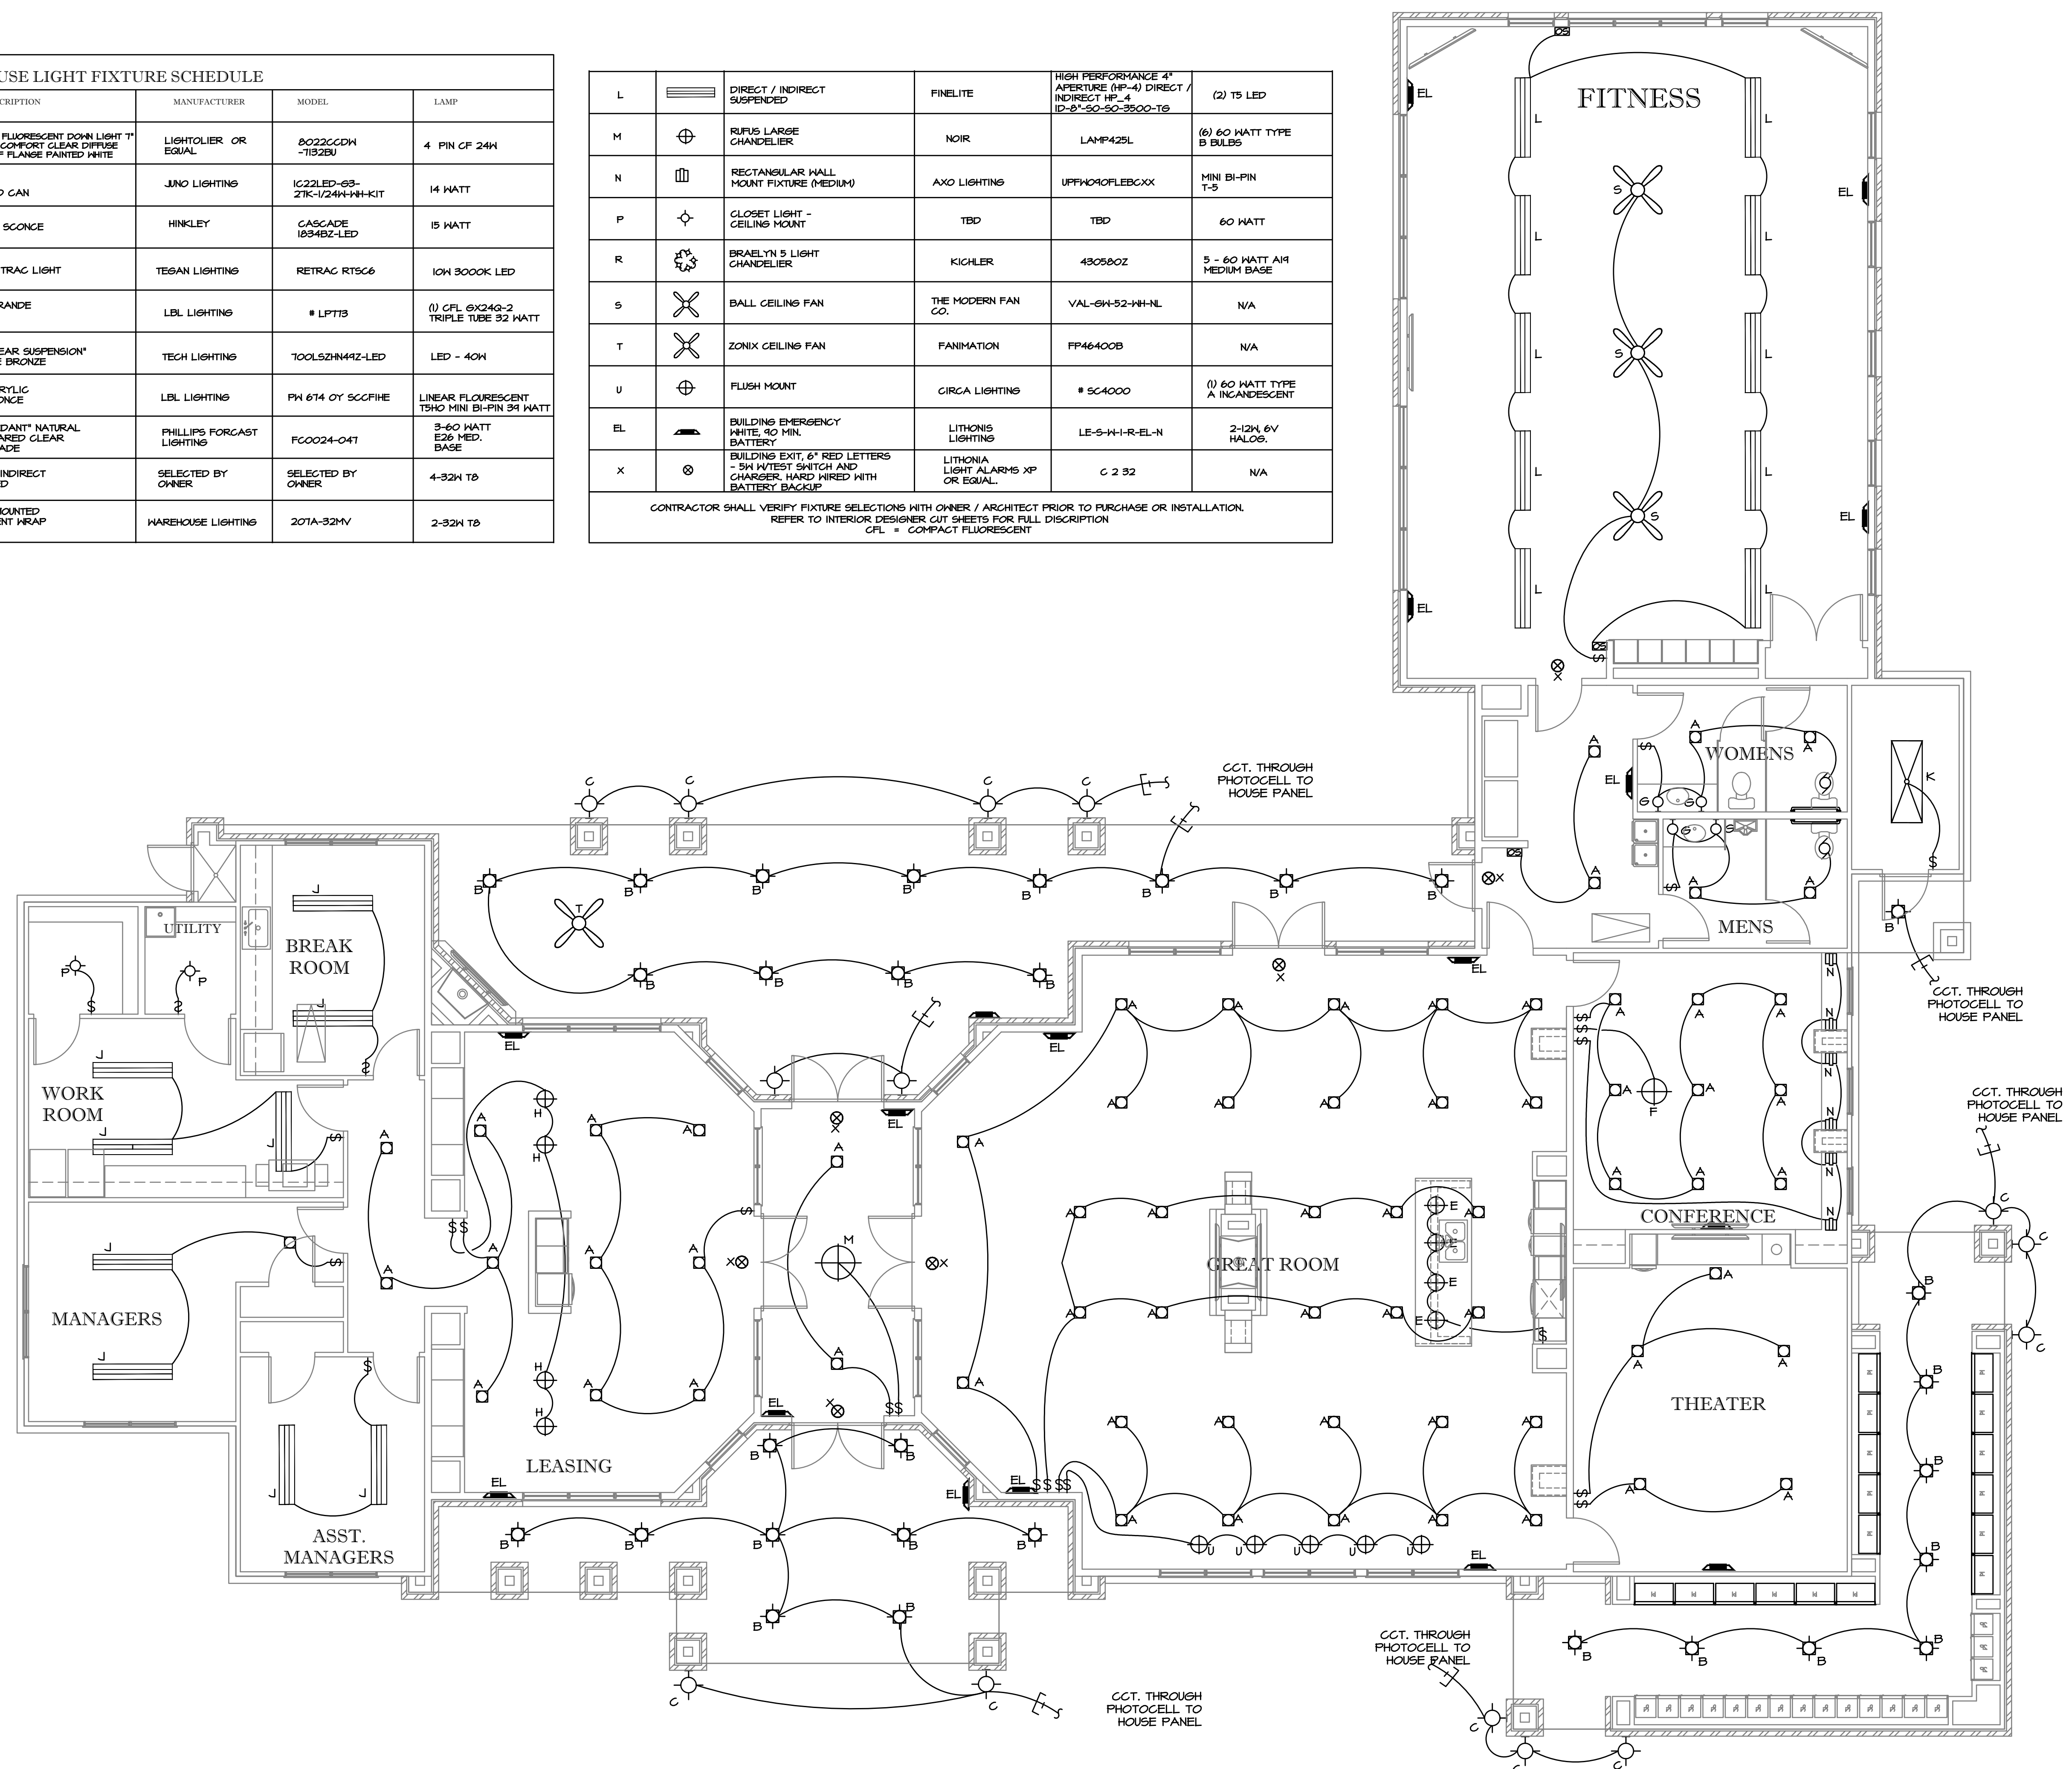

CLUBHOUSE LIGHTING

3/16" = 1'-0"

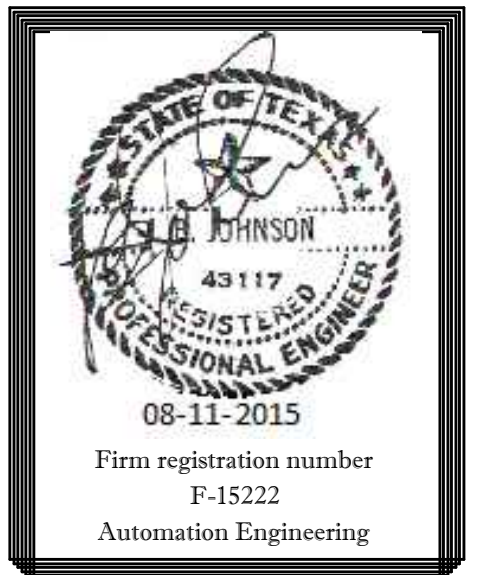

JRF ASSOCIATES
3620 Winding Way
Round Rock, Texas 78664
512-970-9478 Ph

AGORA PALM
SAN ANTONIO
TEXAS

PROJECT NUMBER
1322014
SCALE
3/16" = 1'-0"
ISSUE DATE
CONSTRUCTION SET
07 - 01 - 2015

SHEET NUMBER
E31



JRF ASSOCIATES
 3620 Winding Way
 Round Rock Texas 78664
 512-970-9478 Ph

TEXAS

AGORA PALM


SAN ANTONIO

©2015 BY JRF ASSOCIATES
 ALL RIGHTS RESERVED.
 THE DESIGN(S) DEPICTED HEREIN ARE THE SOLE
 PROPERTY OF JRF ASSOCIATES AND MAY NOT BE
 REPRODUCED IN ANY MANNER WITHOUT THE
 PERMISSION. ALL DESIGN(S) ARE BASED ON THE
 INFORMATION FROM OTHERS AND TO BE USED
 ON AGORA PALM APARTMENTS.


PROJECT NUMBER
 1322014
 SCALE
 3/16" = 1'-0"
 ISSUE DATE
 CONSTRUCTION SET
 07 - 01 - 2015

SHEET NUMBER


E32

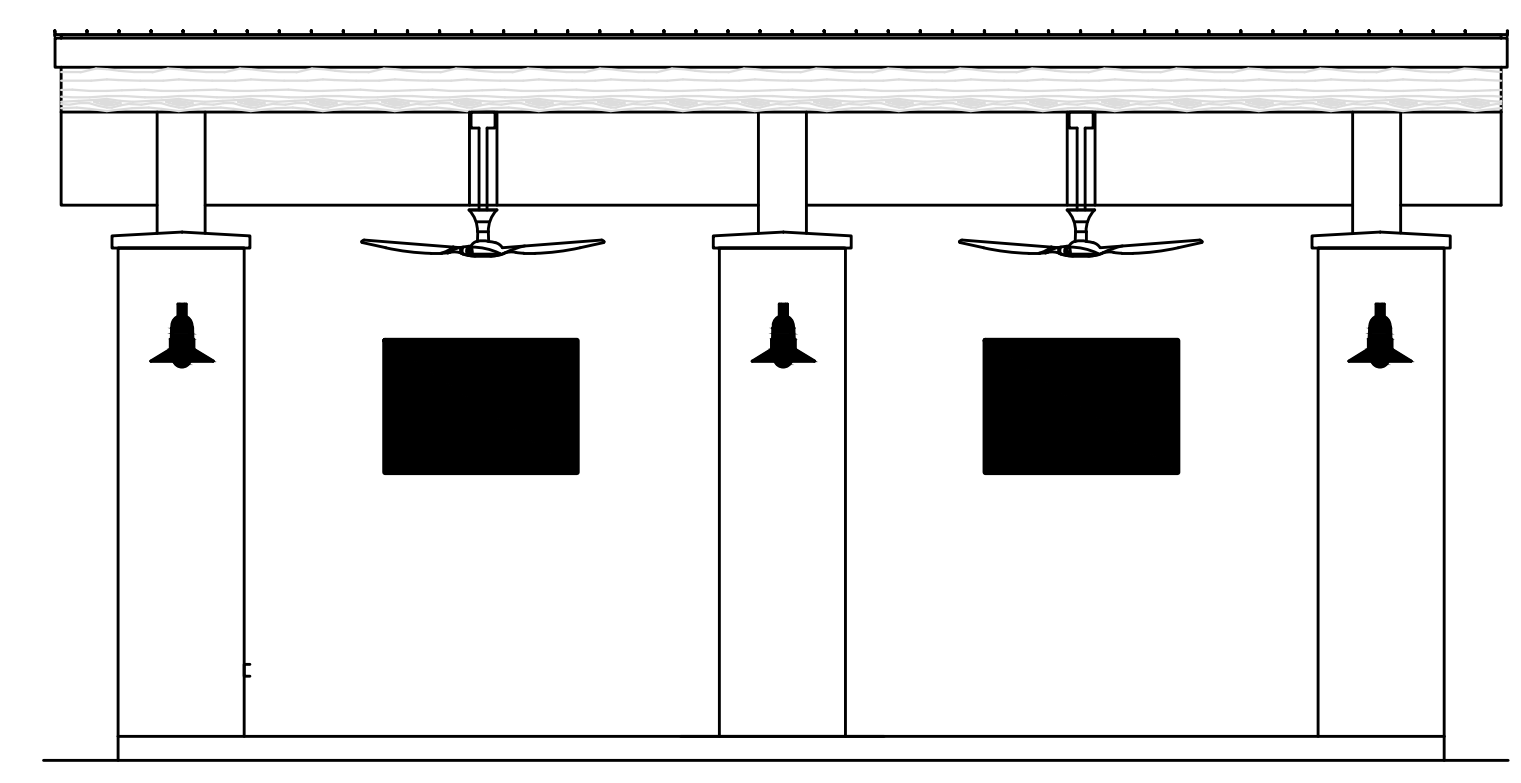


FRONT VIEW - LIGHTING
 N.T.S.

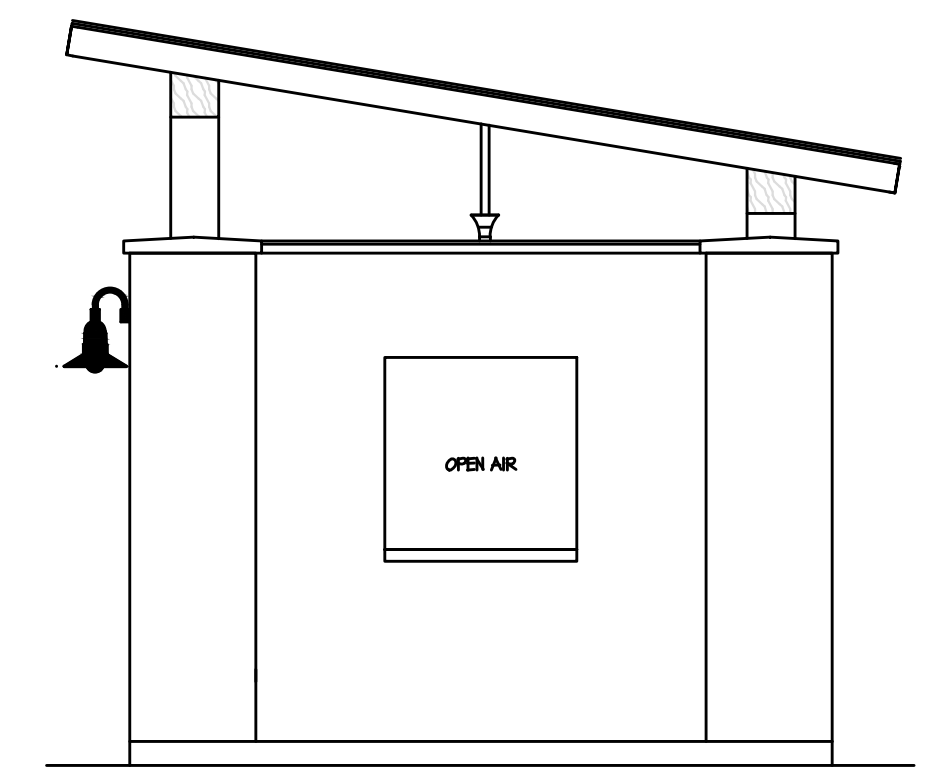

RIGHT SIDE VIEW LIGHTING
 N.T.S.

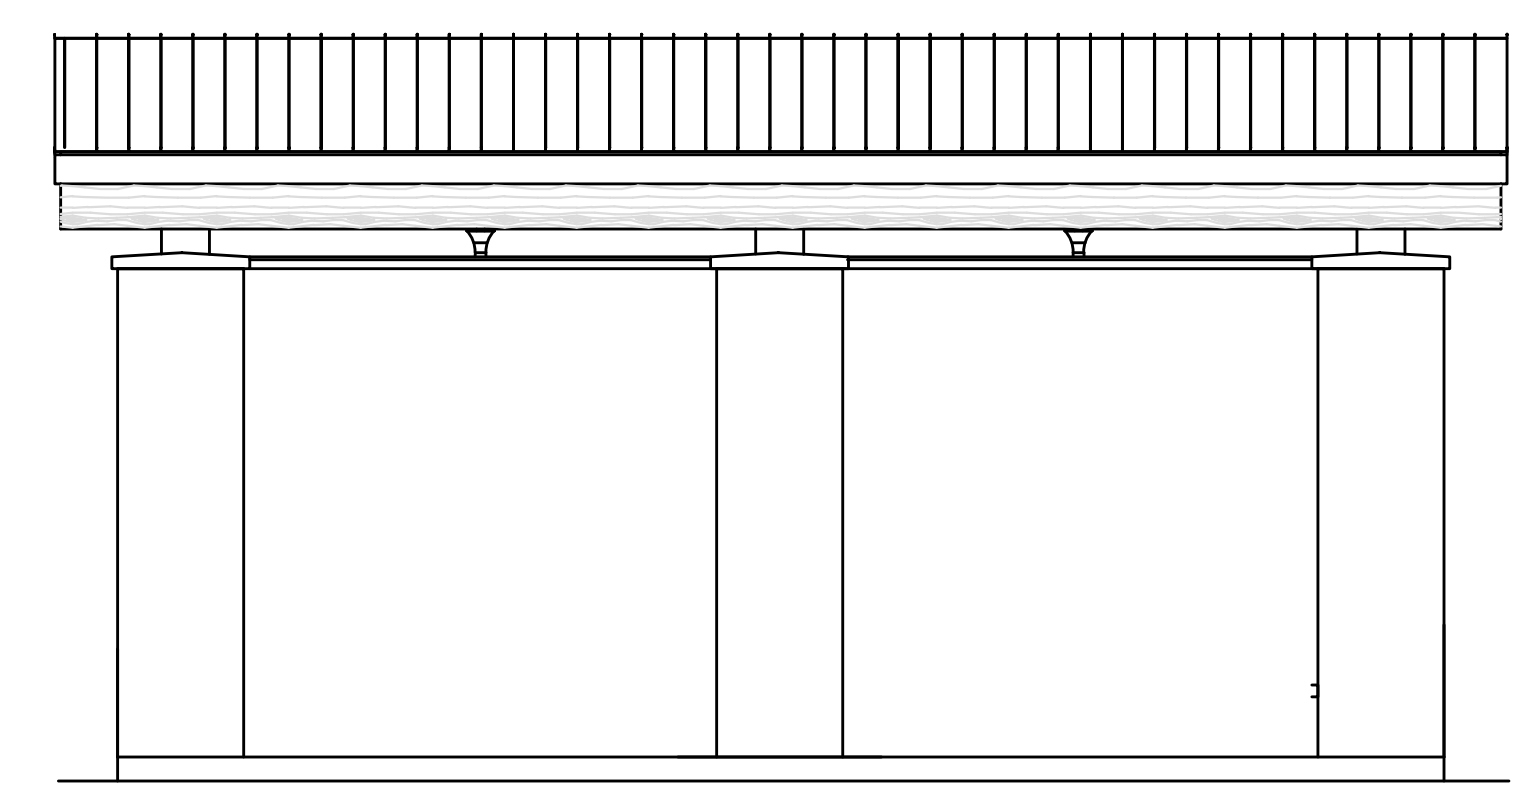


REAR VIEW - LIGHTING
 N.T.S.

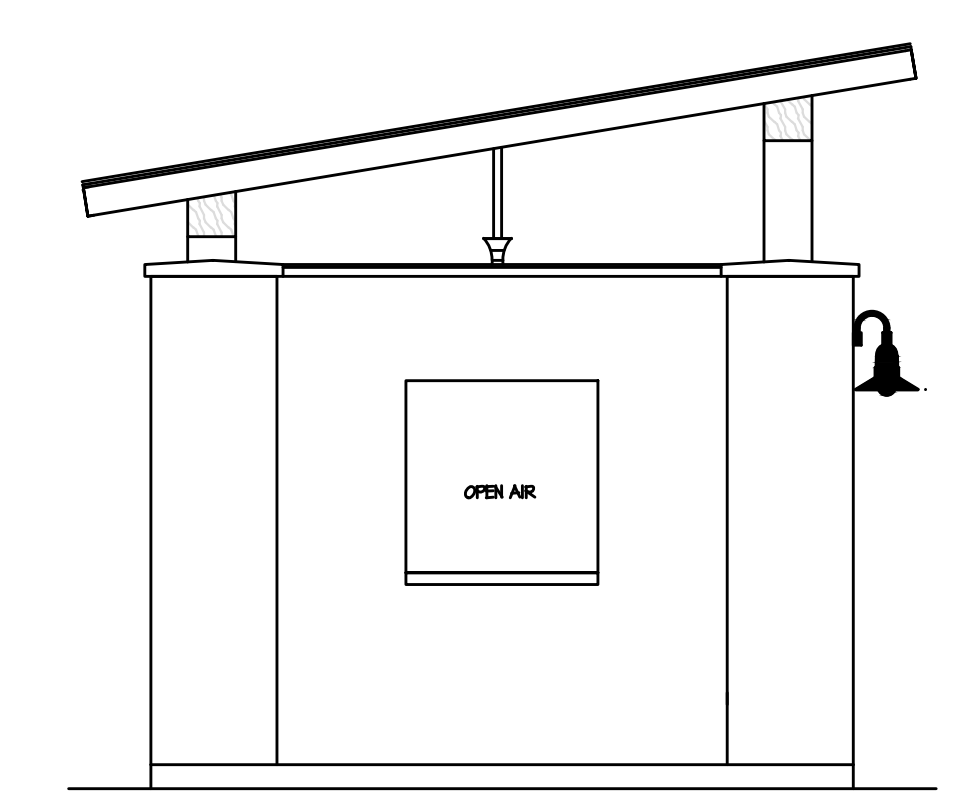

LEFT SIDE VIEW LIGHTING
 N.T.S.

CABANA LIGHT FIXTURES				
SYMBOL	DISCRIPTION	LAMP	MODEL	MANUFACTURER
□	WALL MOUNT WALL SCONCE	1-18W	-	TO BE SELECTED BY OWNER
✪	52" CEILING FAN W/LIGHT KIT	3-13W	-	TO BE SELECTED BY OWNER

ALL LIGHT FIXTURES SHALL BE UL LISTED FOR "SELF BALLAST" COMPACT FLUORESENT AND LED LAMPS.

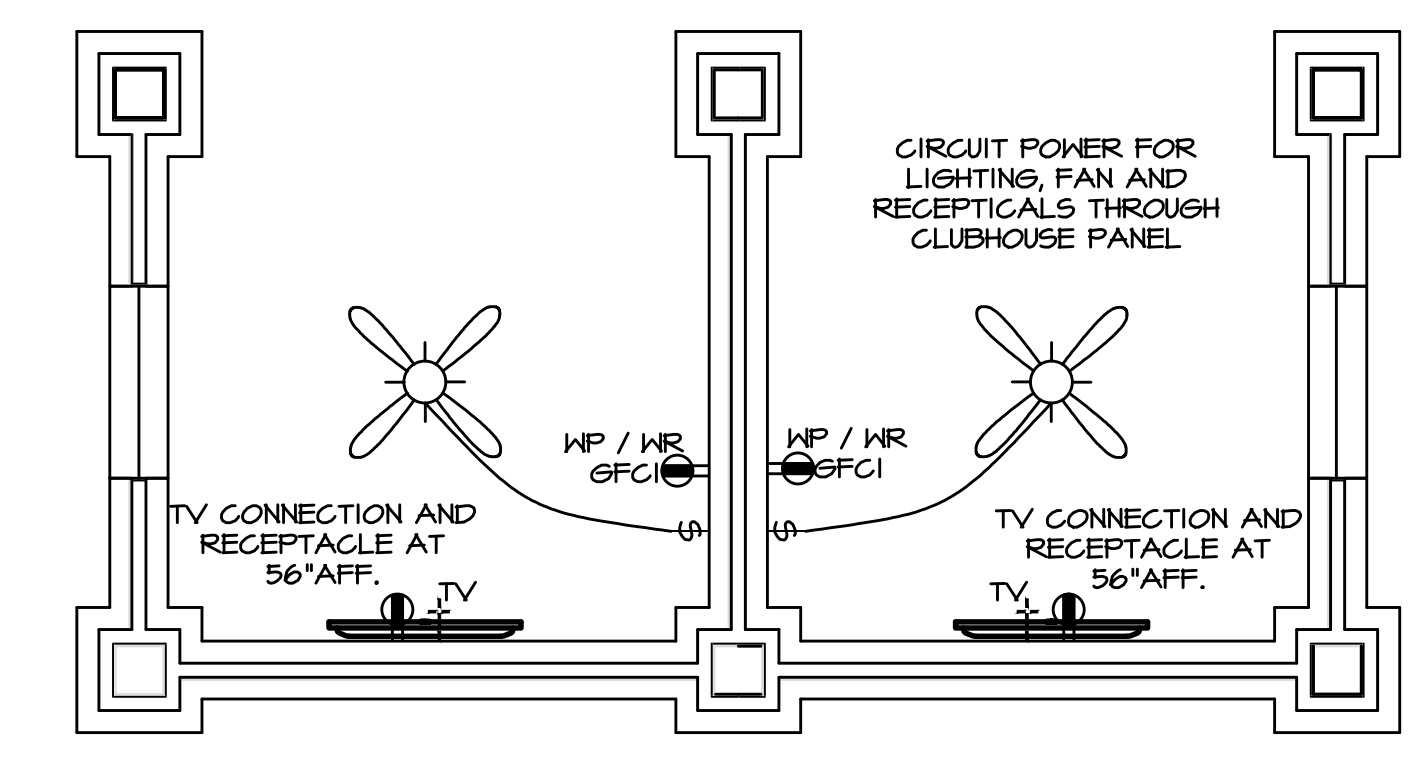

CABANA POWER
 N.T.S.