



ELECTRICAL SYMBOLS LEGEND	
	110V OUTLET - MTD 15" A.F.F. 10 BOTTOM OF PLATE
	220V OUTLET - MTD 15" A.F.F. 10 BOTTOM OF PLATE
	COUNTER TOP GFI OUTLET 110V, MTD, ABOVE COUNTER
	1/2 SWITCHED OUTLET - MTD, UNDER COUNTER
	FLOOR MOUNTED VOICE/DATA OUTLET
	FLOOR MOUNTED OUTLET 110V
	3-WAY LIGHT SWITCH - MTD 48" A.F.F. TO TOP OF SWITCH 120V
	LIGHT SWITCH - MTD 48" A.F.F. TO TOP OF SWITCH 120V
	INDICATES MOTION SENSOR ON SWITCH
	INDICATES DIMMER ON SWITCH
	TELEPHONE/ DATA OUTLET - MTD 15" A.F.F. TO BOTTOM OF PLATE
	TELEPHONE OUTLET - MTD 15" A.F.F. TO BOTTOM OF PLATE
	DATA OUTLET - MTD 15" A.F.F. TO BOTTOM OF PLATE
	KITCHEN SINK DISPOSAL MOTOR 110V
	ELECTRICAL DISCONNECT
	ELECTRICAL JUNCTION BOX
	RANGE HOOD EXHAUST FAN
	THERMOSTAT - MTD 48" A.F.F. TO TOP OF THERMOSTAT
	FIRE ALARM CONTROL PANEL
	SMOKE DETECTOR
	DUPLEX WALL OUTLET
	TELEPHONE WALL OUTLET
	CABLE/TV WALL OUTLET
	2 USB INSERTS WITH SINGLE 110V OUTLET - REFER TO ARCH FOR MTD HEIGHTS

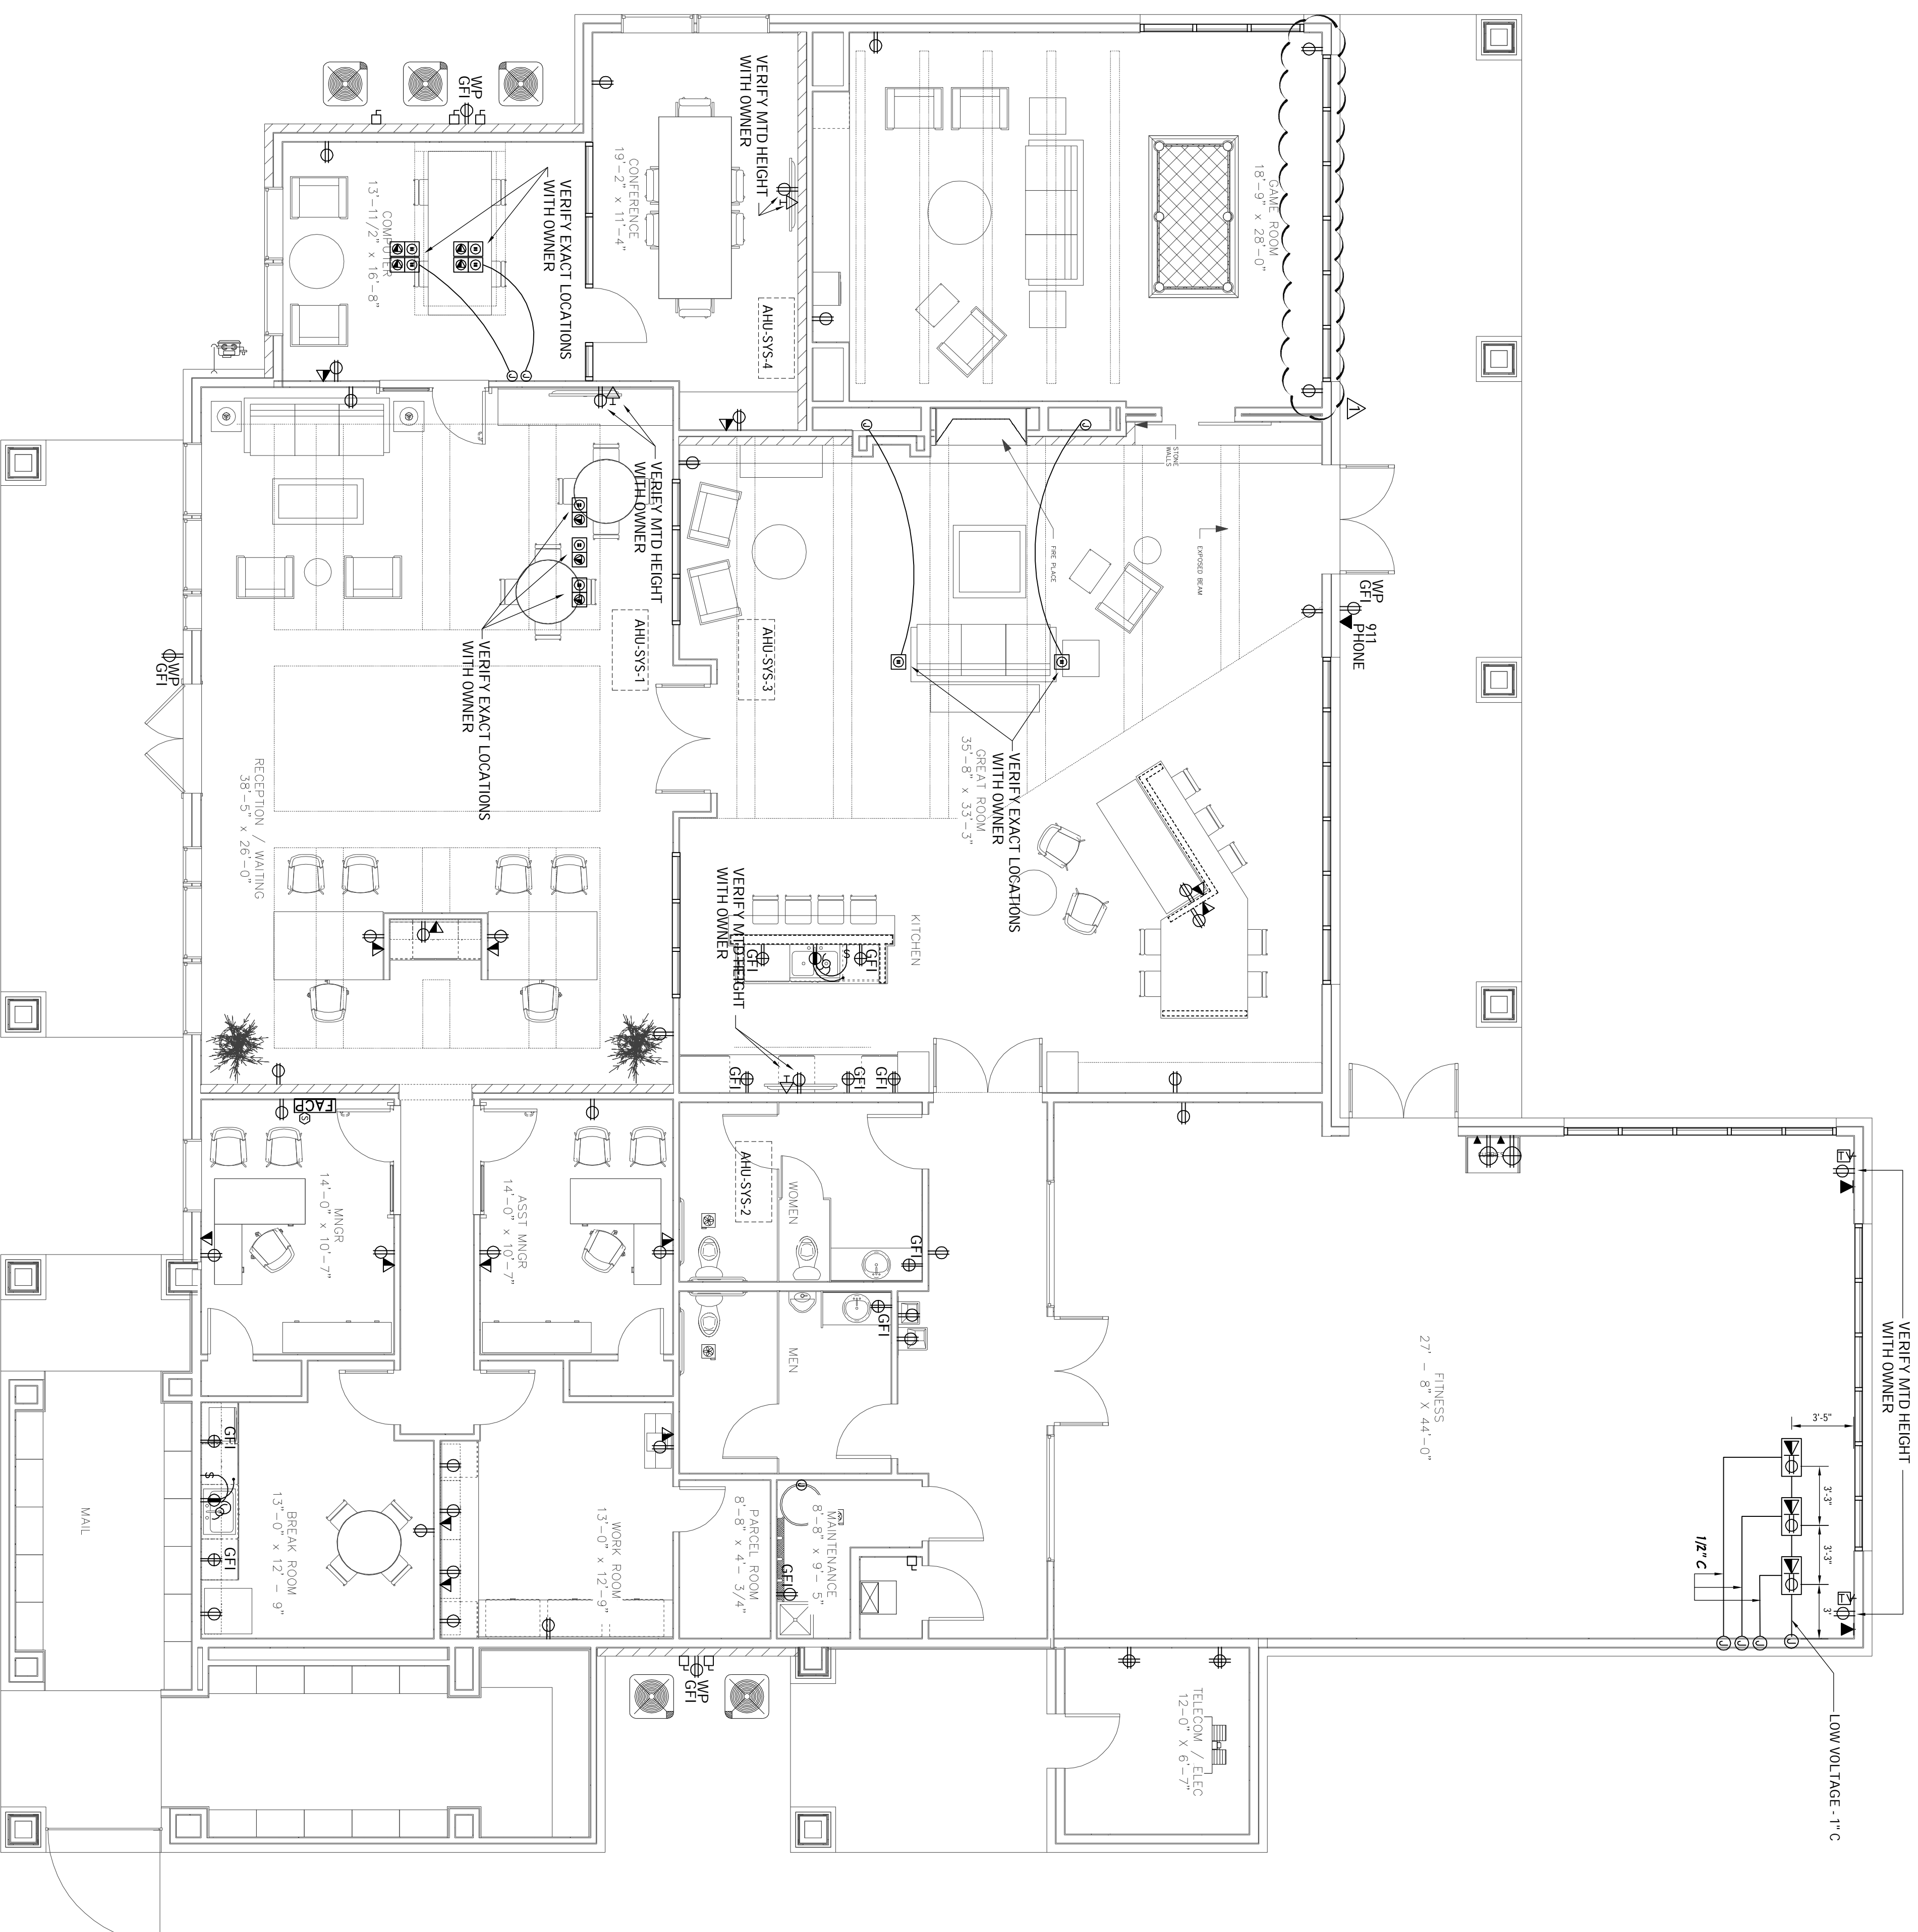

1 CLUBHOUSE FLOOR PLAN

ELECTRICAL POWER LAYOUT

SCALE: 3/8" = 1'-0"

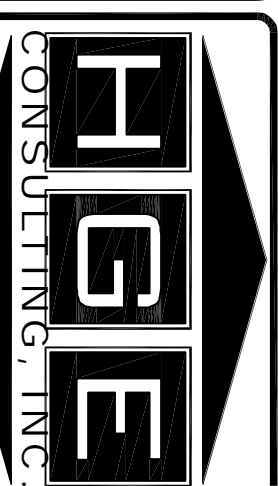


MEP ENGINEERS

15603 GLEN CHASE
HOUSTON, TEXAS 77095
PHONE: 281-859-7682
FAX: 281-859-2198
E-mail: ME@HGECONSULTING.COM

REVISIONS:
NO. DATE BY DESCRIPTION
1 01-07-16 JA REVISION 5

NUMBER	DATE	DESCRIPTION
1	01-07-16	REVISION 5

KINGSLAND APTS.
HARRIS COUNTY, TEXAS

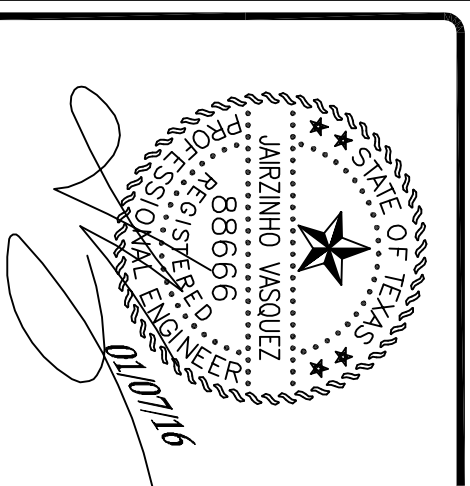

PROGRESS SET
PERMIT ISSUE
CONSTRUCTION ISSUE
DATE: 08/17/2015
DRAWN BY: JA
CHK'D BY: JV
JOB: 919-15

E-3.1.2